


THIS DRAWING IS THE PROPERTY OF THE DESIGN ASSOCIATES INC. AND SHALL NOT BE COPIED OR USED IN ANY MANNER WITHOUT PRIOR PERMISSION.

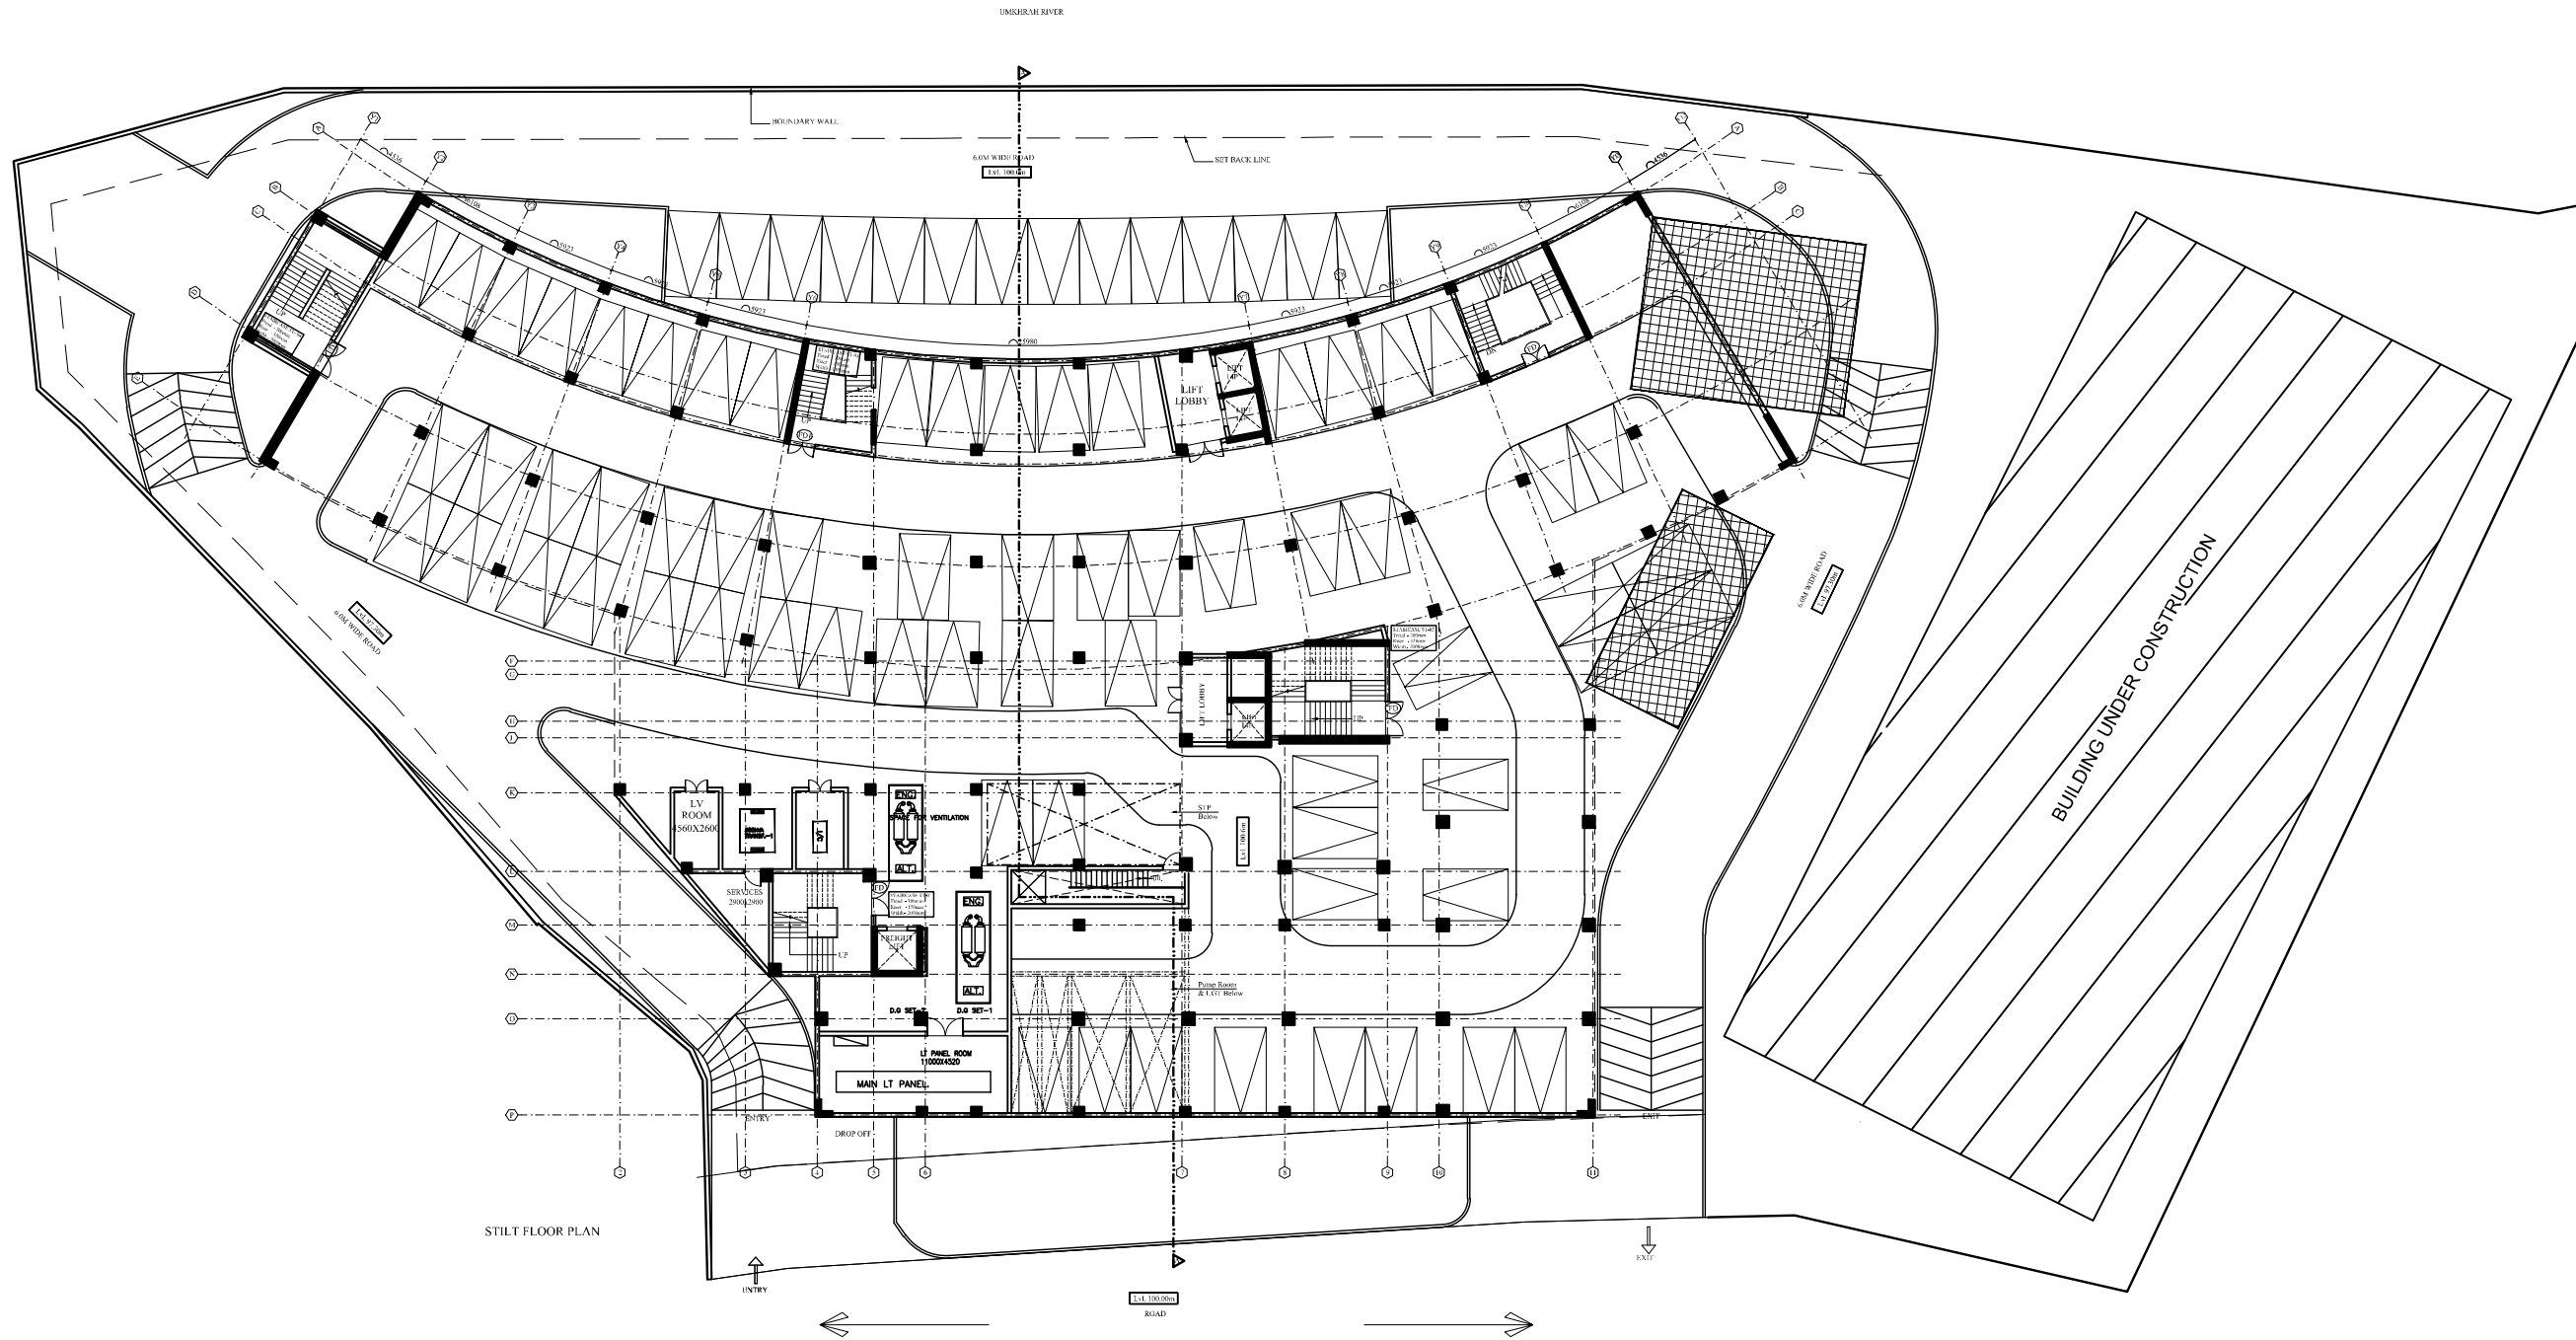

NOTES:-

1. ALL DIMENSIONS ARE IN MM.
2. ALL DIMENSIONS ARE TO BE READ AND NOT MEASURED.
3. ALL LEVELS ARE IN MM.
4. GRID DIMENSIONS AND PLOT LINES ARE TO BE STRICTLY ADHERED TO.
5. ALL LEVELS INCLUDING FLOOR LEVELS, CILL & LINTEL LEVELS, LANDING LEVELS, PARAPET HEIGHT/ LEVELS, LEVELS OF HORIZONTAL PROJECTION & BONDS INCLUDING ANY SURFACE FEATURES INDICATED IN THE DRAWINGS ARE TO BE STRICTLY ADHERED TO.

MARK	DATE	DESCRIPTION

MECHANICAL CONSULTANT-
ARK CONSULTANTS
NEW DELHI

ELECTRICAL CONSULTANT-
ARK CONSULTANTS
NEW DELHI

PLUMBING CONSULTANT-
ARK CONSULTANTS
NEW DELHI

STRUCTURE CONSULTANT-
CE CON ENGG.
NEW DELHI

ARCHITECTS-
DESIGN ASSOCIATES INC.
A-163, Sector-136, Noida 201301
PH. :0120-2428600, Fax: 0120-4778530
e-mail: sachin.agarwal@designassociates.in

PROJECT-
COMMERCIAL COMPLEX
AT POLO MARKET
SHILLONG

DRAWING TITLE-
STILT FLOOR PLAN

DRAWING PURPOSE-
FOR TENDER PURPOSES ONLY

JOB NO. - ---	DWG. REF. NO.- ---	DATE- 30.08.2018
SCALE- 1:100	REVISION- ---	DATE OF ISSUE- ---
DWG. NO.- PM/CD/AR/101		

	SHEET SIZE- A3	SHEET NO- 01/01
	DRAWN BY- --	CHECKED BY- SACHIN



THIS DRAWING IS THE PROPERTY OF THE DESIGN ASSOCIATES INC. AND SHALL NOT BE COPIED OR USED IN ANY MANNER WITHOUT PRIOR PERMISSION.

- NOTES:-
1. ALL DIMENSIONS ARE IN MM.
 2. ALL DIMENSIONS ARE TO BE READ AND NOT MEASURED.
 3. ALL LEVELS ARE IN MM.
 4. GRID DIMENSIONS AND PLOT LINES ARE TO BE STRICTLY ADHERED TO.
 5. ALL LEVELS INCLUDING FLOOR LEVELS, CILL & LINTEL LEVELS, LANDING LEVELS, PARAPET HEIGHT/ LEVELS, LEVELS OF HORIZONTAL PROJECTION & BONDS INCLUDING ANY SURFACE FEATURES INDICATED IN THE DRAWINGS ARE TO BE STRICTLY ADHERED TO.

MARK	DATE	DESCRIPTION

MECHANICAL CONSULTANT-
ARK CONSULTANTS
NEW DELHI

ELECTRICAL CONSULTANT-
ARK CONSULTANTS
NEW DELHI

PLUMBING CONSULTANT-
ARK CONSULTANTS
NEW DELHI

STRUCTURE CONSULTANT-
CE CON ENGG.
NEW DELHI

ARCHITECTS-
DESIGN ASSOCIATES INC.
ARCHITECTS
A-163, Sector-136, Noida 201301
PH. :0120-2428600, Fax: 0120-4778530
e-mail: sachin.agarwal@designassociates.in

PROJECT-
**COMMERCIAL COMPLEX
AT POLO MARKET
SHILLONG**


DRAWING TITLE-
GROUND FLOOR PLAN

DRAWING PURPOSE-
FOR TENDER PURPOSES ONLY

JOB NO. - ---	DWG. REF. NO. - ---	DATE - 30.08.2018
SCALE - 1:100	REVISION - ---	DATE OF ISSUE - ---

DWG. NO. -
PM/CD/AR/102

SHEET SIZE - A3	SHEET NO. - 01/01
DRAWN BY - --	CHECKED BY - SACHIN

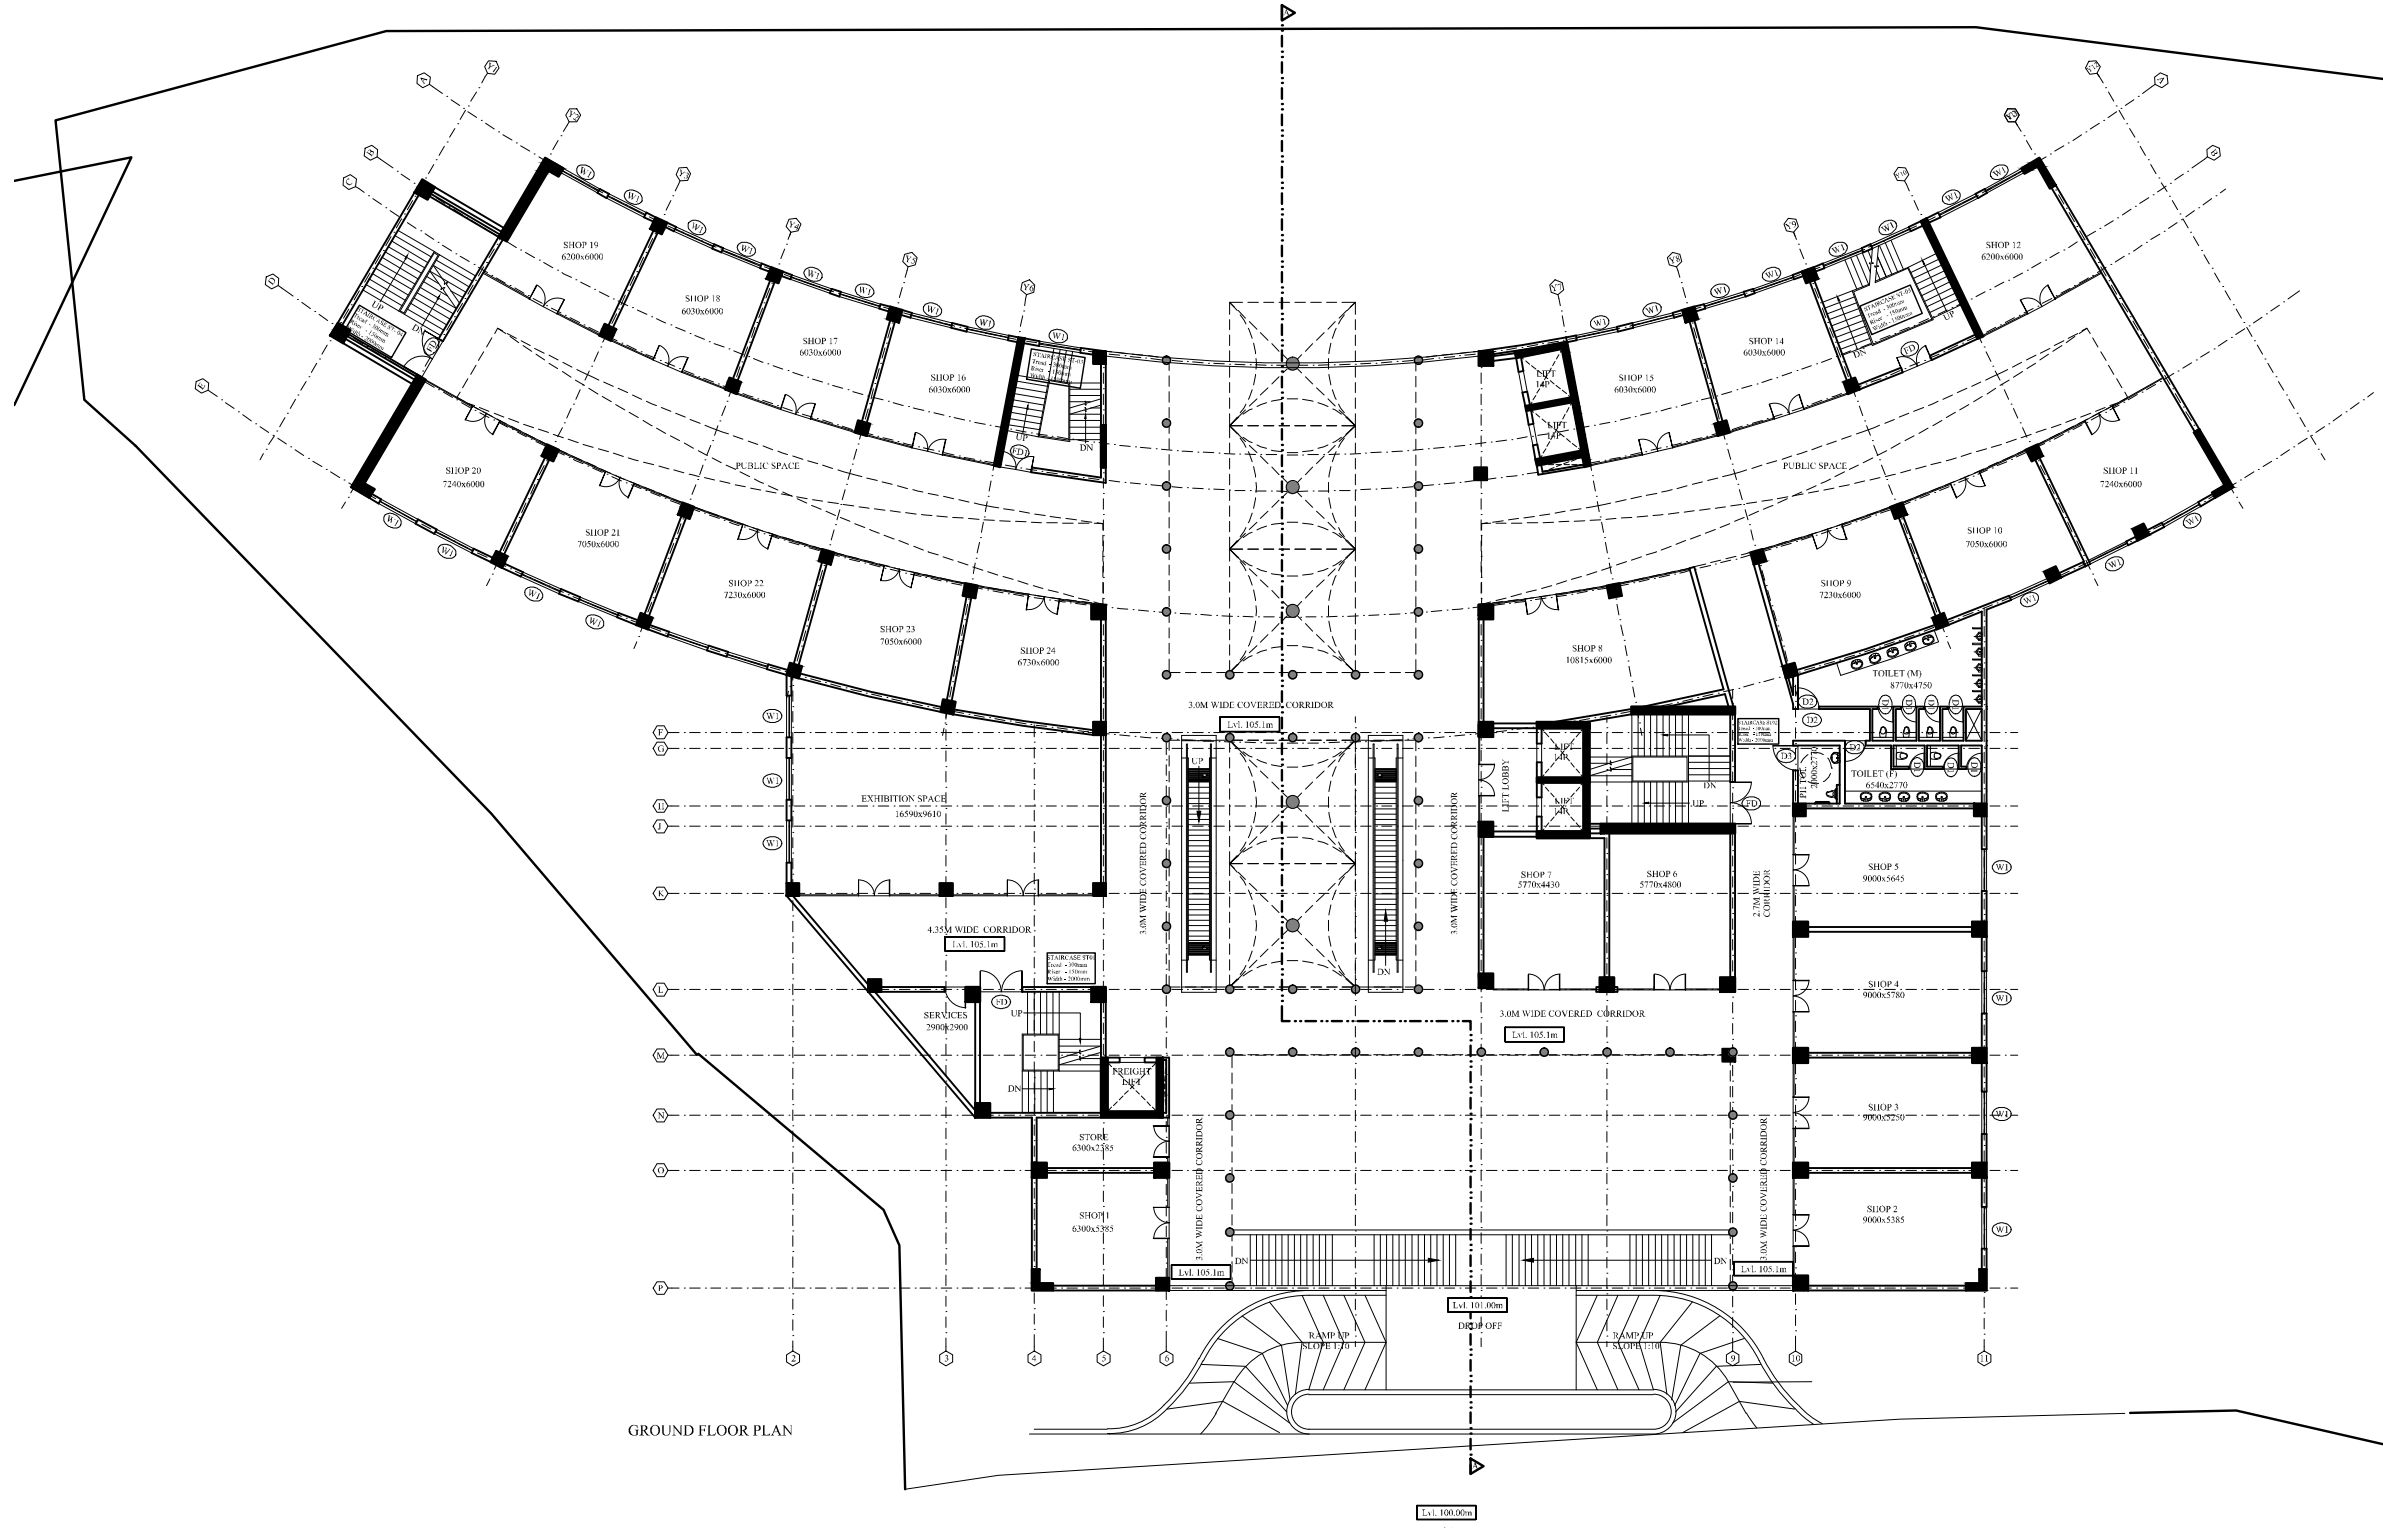

THIS DRAWING IS THE PROPERTY OF THE DESIGN ASSOCIATES INC. AND SHALL NOT BE COPIED OR USED IN ANY MANNER WITHOUT PRIOR PERMISSION.

NOTES:-

1. ALL DIMENSIONS ARE IN MM.
2. ALL DIMENSIONS ARE TO BE READ AND NOT MEASURED.
3. ALL LEVELS ARE IN MM.
4. GRID DIMENSIONS AND PLOT LINES ARE TO BE STRICTLY ADHERED TO.
5. ALL LEVELS INCLUDING FLOOR LEVELS, CILL & LINTEL LEVELS, LANDING LEVELS, PARAPET HEIGHT/ LEVELS, LEVELS OF HORIZONTAL PROJECTION & BONDS INCLUDING ANY SURFACE FEATURES INDICATED IN THE DRAWINGS ARE TO BE STRICTLY ADHERED TO.

MARK	DATE	DESCRIPTION

MECHANICAL CONSULTANT-

ARK CONSULTANTS
NEW DELHI

ELECTRICAL CONSULTANT-

ARK CONSULTANTS
NEW DELHI

PLUMBING CONSULTANT-

ARK CONSULTANTS
NEW DELHI

STRUCTURE CONSULTANT-

CE CON ENGG.
NEW DELHI

ARCHITECTS-



A-163, Sector-136, Noida 201301
PH. :0120-2428600, Fax: 0120-4778530
e-mail: sachin.agarwal@designassociates.in

PROJECT-

COMMERCIAL COMPLEX
AT POLO MARKET
SHILLONG

DRAWING TITLE-

FIRST FLOOR PLAN

DRAWING PURPOSE-


FOR TENDER PURPOSES ONLY

JOB NO. -	DWG. REF. NO. -	DATE-
---	---	30.08.2018

SCALE-	REVISION-	DATE OF ISSUE-
1:100	---	---

DWG. NO. -
PM/CD/AR/103


	SHEET SIZE-	SHEET NO-
	A3	01/01
DRAWN BY-	CHECKED BY-	
--	SACHIN	

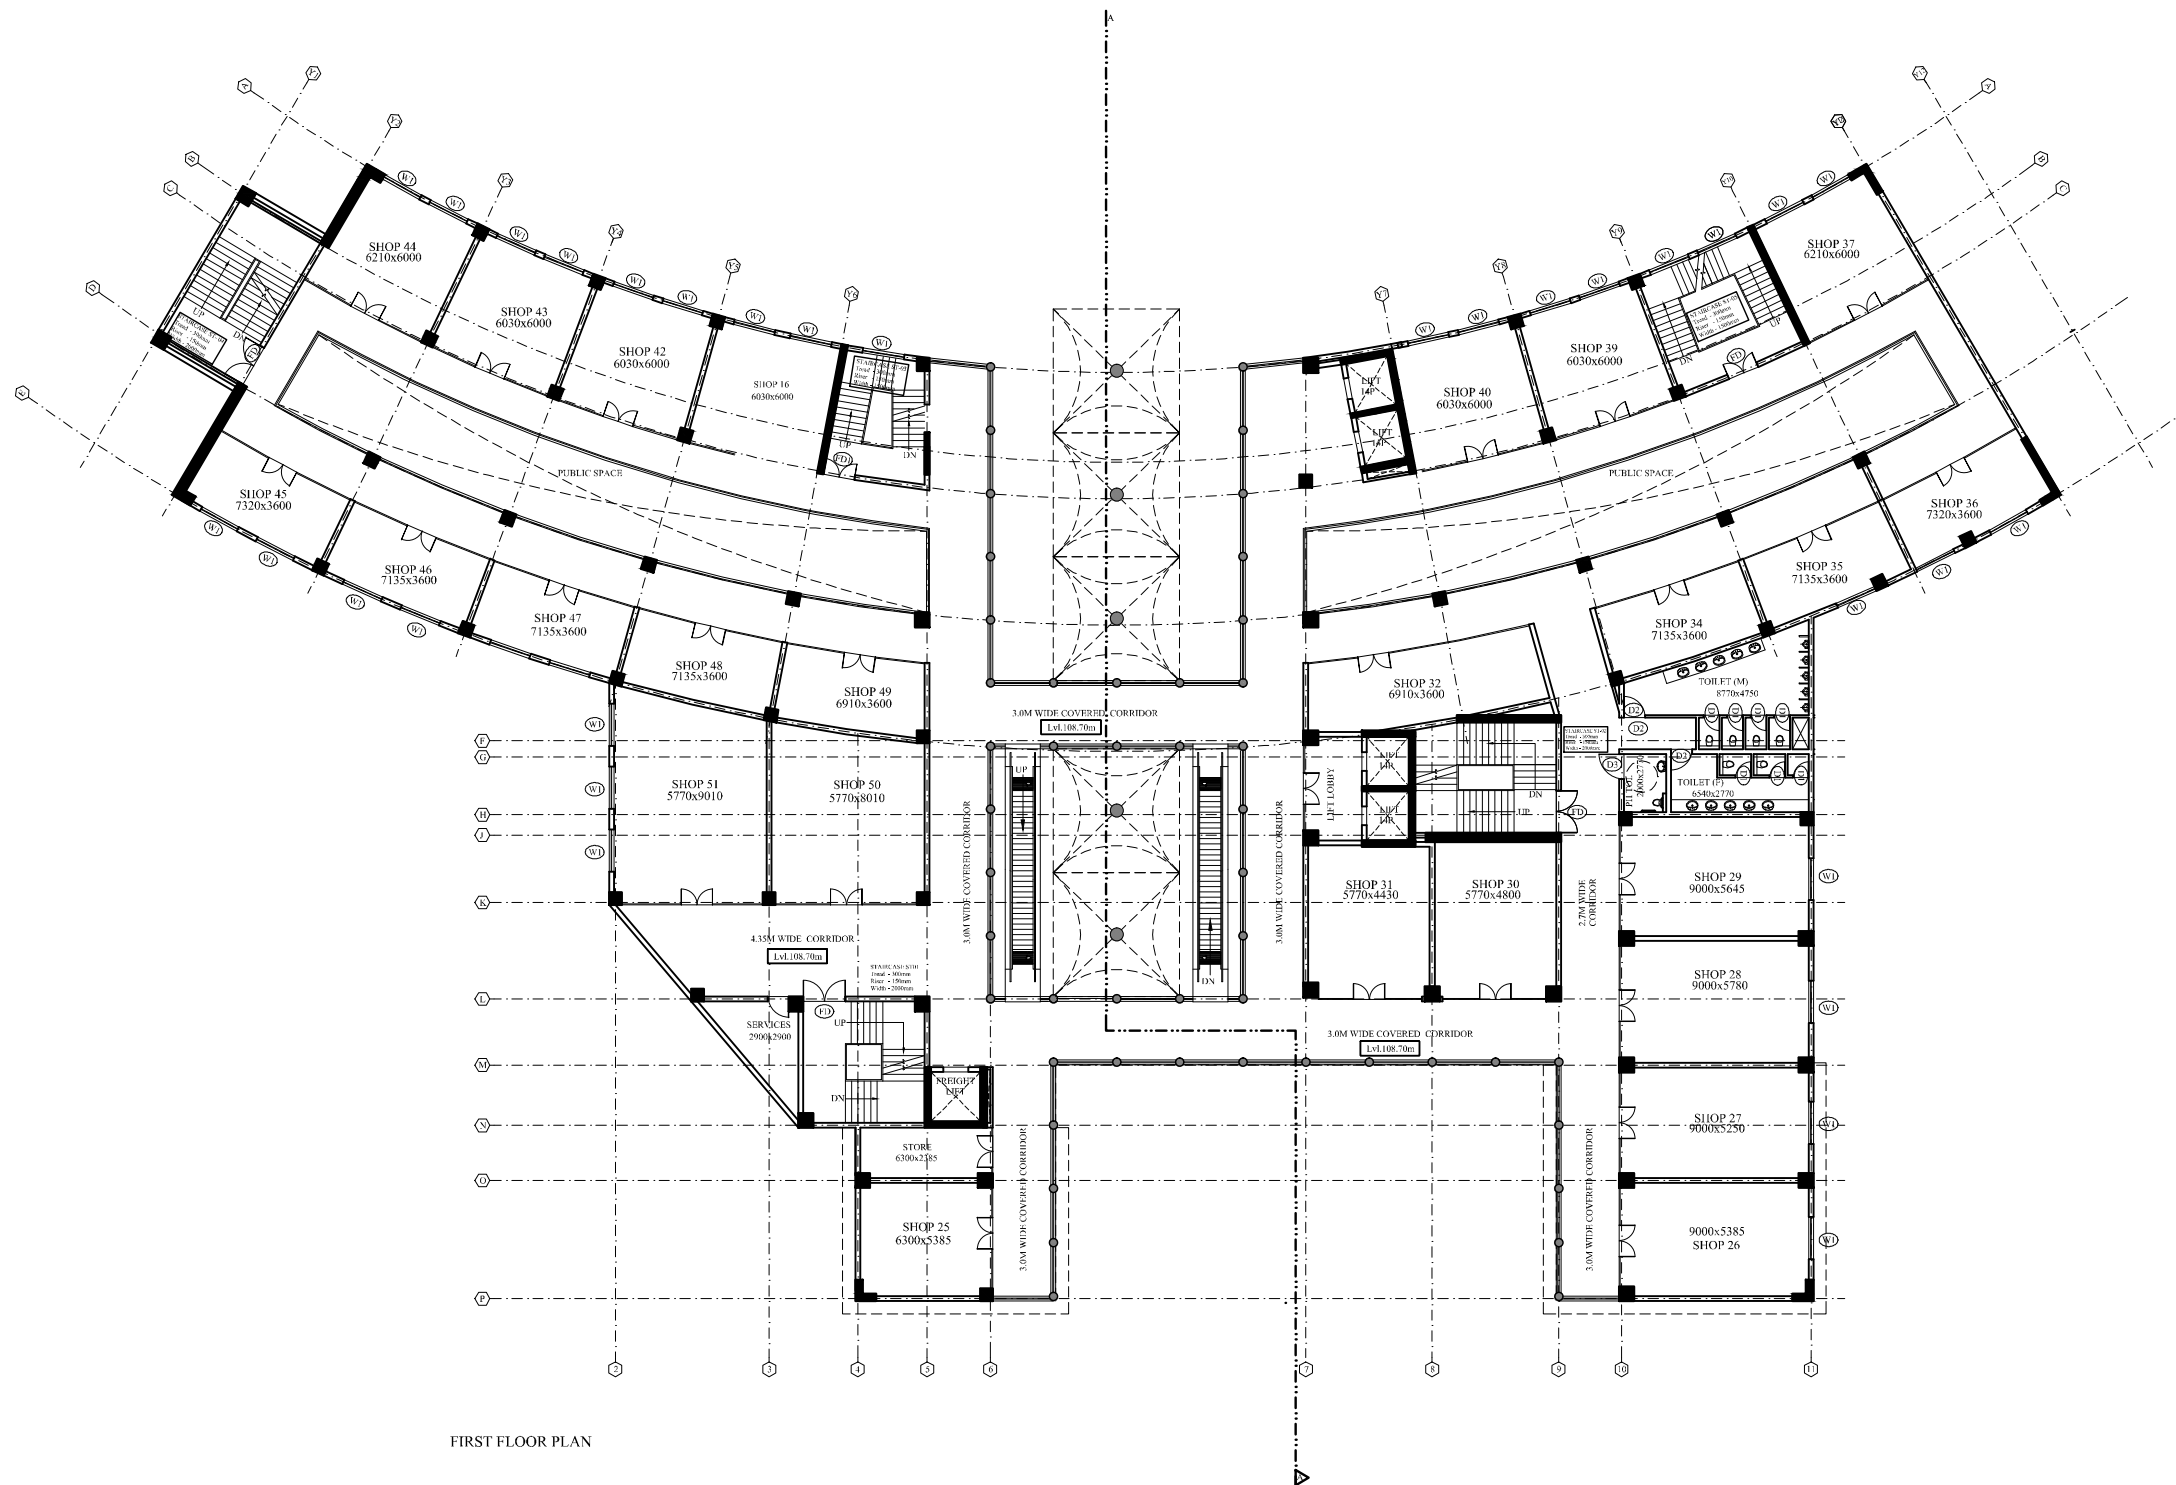

FIRST FLOOR PLAN



THIS DRAWING IS THE PROPERTY OF THE DESIGN ASSOCIATES INC. AND SHALL NOT BE COPIED OR USED IN ANY MANNER WITHOUT PRIOR PERMISSION.

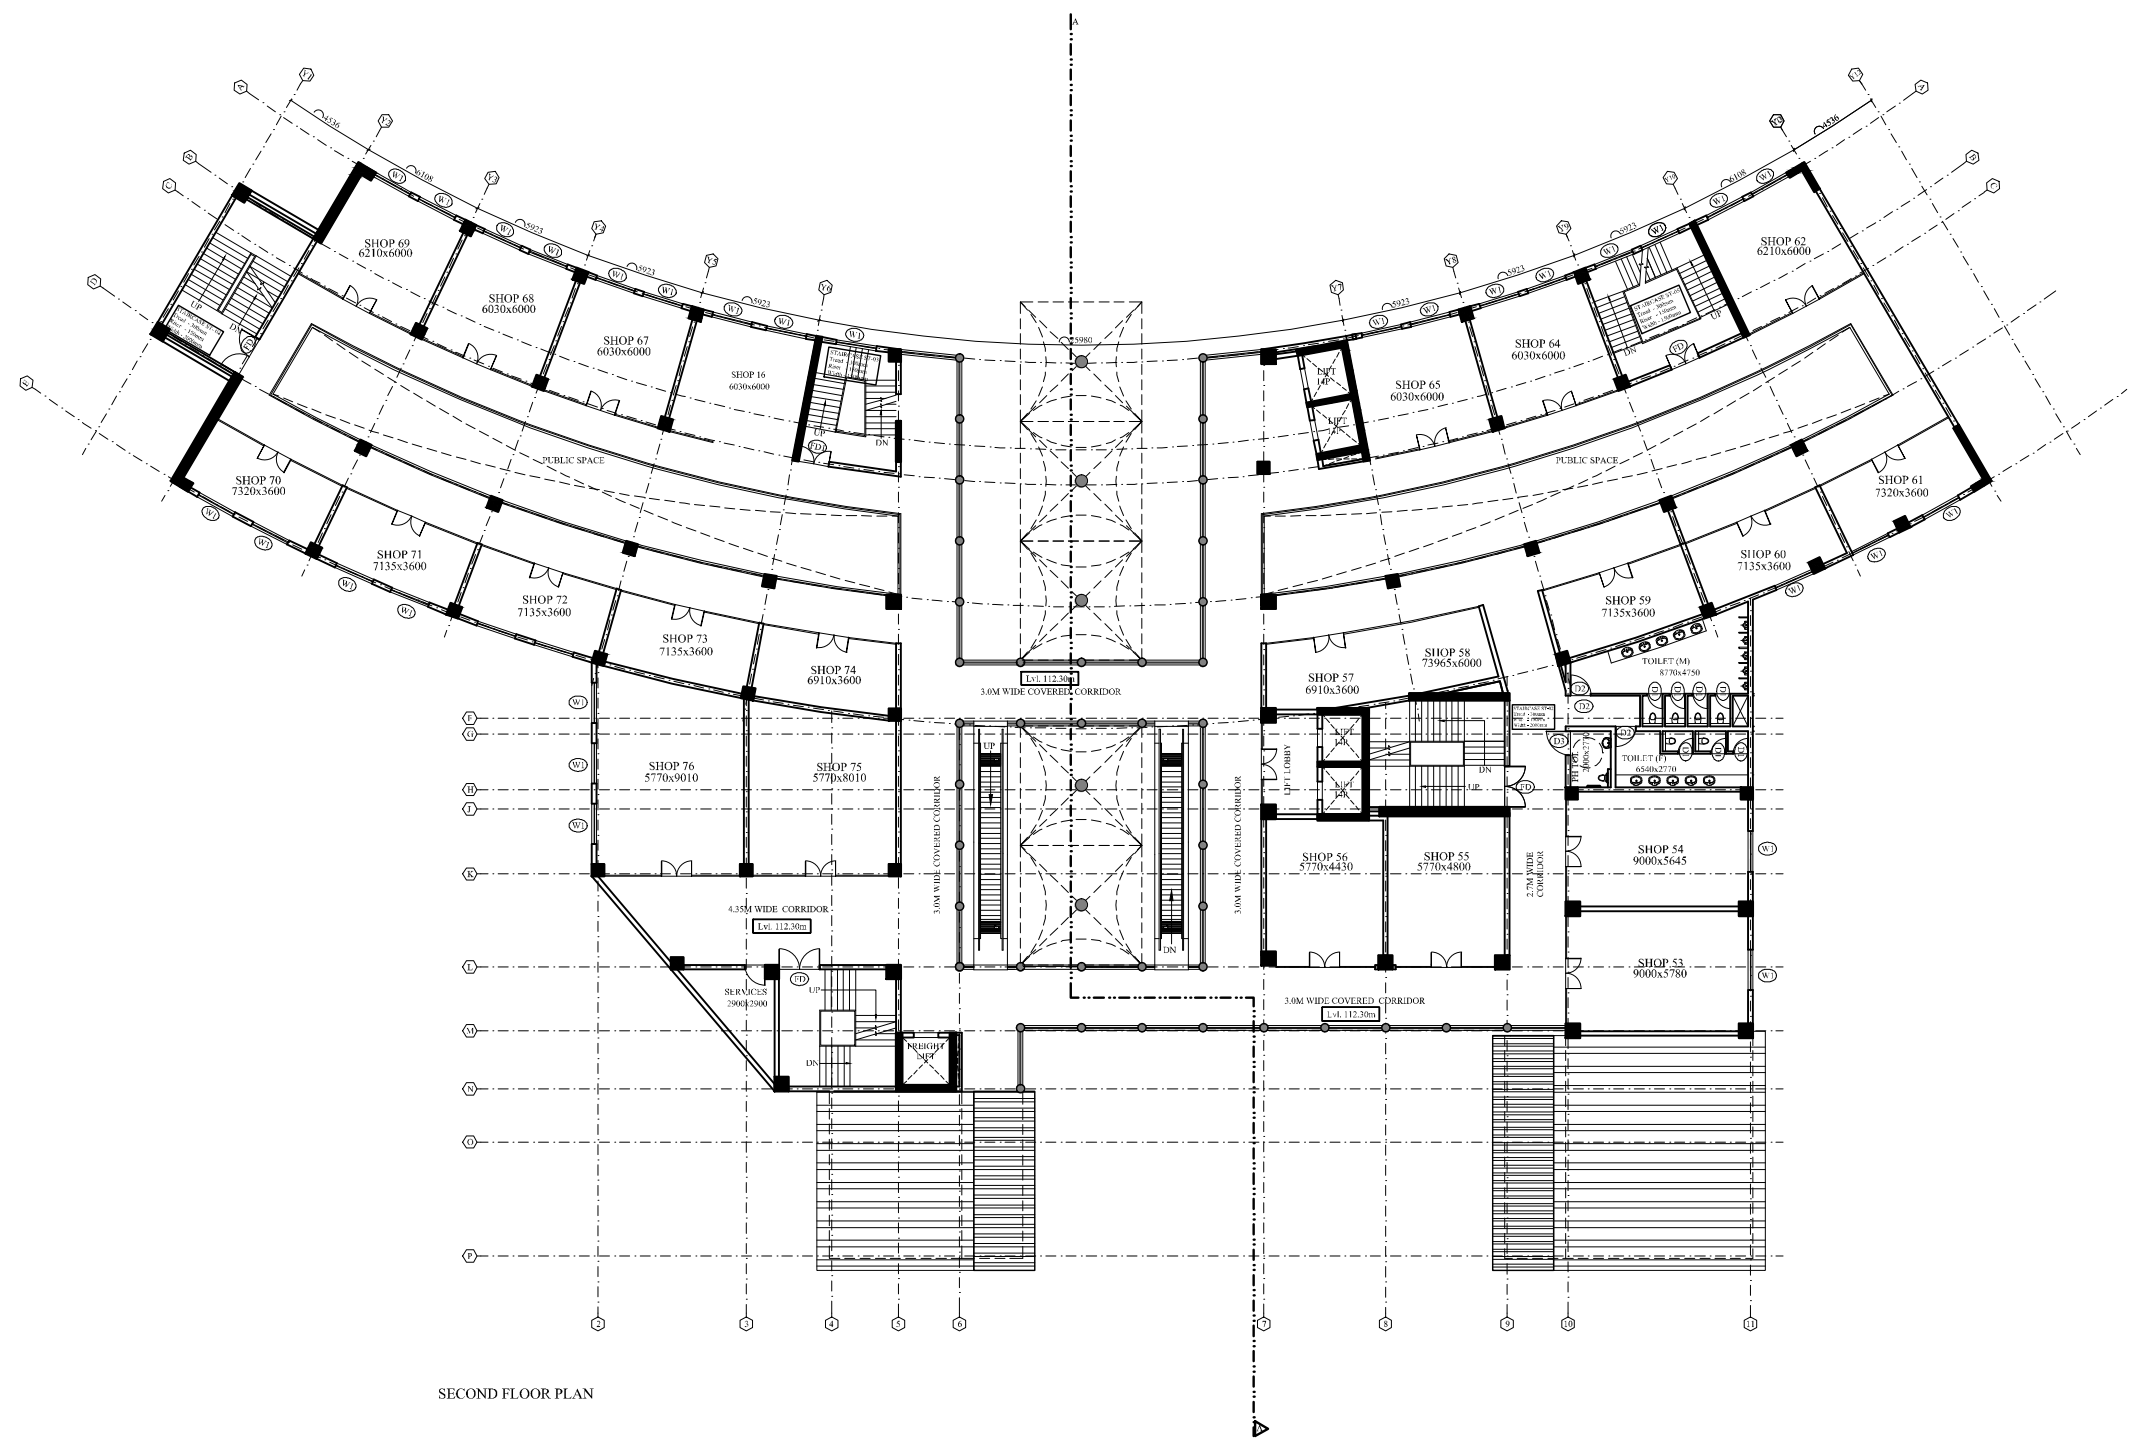

SECOND FLOOR PLAN

NOTES:-

1. ALL DIMENSIONS ARE IN MM.
2. ALL DIMENSIONS ARE TO BE READ AND NOT MEASURED.
3. ALL LEVELS ARE IN MM.
4. GRID DIMENSIONS AND PLOT LINES ARE TO BE STRICTLY ADHERED TO.
5. ALL LEVELS INCLUDING FLOOR LEVELS, CILL & LINTEL LEVELS, LANDING LEVELS, PARAPET HEIGHT/ LEVELS, LEVELS OF HORIZONTAL PROJECTION & BONDS INCLUDING ANY SURFACE FEATURES INDICATED IN THE DRAWINGS ARE TO BE STRICTLY ADHERED TO.

MARK	DATE	DESCRIPTION

MECHANICAL CONSULTANT-
ARK CONSULTANTS
NEW DELHI

ELECTRICAL CONSULTANT-
ARK CONSULTANTS
NEW DELHI

PLUMBING CONSULTANT-
ARK CONSULTANTS
NEW DELHI

STRUCTURE CONSULTANT-
CE CON ENGG.
NEW DELHI

ARCHITECTS-



A-163, Sector-136, Noida 201301
PH. :0120-2428600, Fax: 0120-4778530
e-mail: sachin.agarwal@designassociates.in

PROJECT-

COMMERCIAL COMPLEX
AT POLO MARKET
SHILLONG

DRAWING TITLE-

SECOND FLOOR PLAN

DRAWING PURPOSE-

FOR TENDER PURPOSES ONLY

JOB NO. - ---	DWG. REF. NO. - ---	DATE- 30.08.2018
SCALE- 1:100	REVISION- ---	DATE OF ISSUE- ---


DWG. NO.-

PM/CD/AR/104

	SHEET SIZE- A3	SHEET NO- 01/01
	DRAWN BY- --	CHECKED BY- SACHIN



THIS DRAWING IS THE PROPERTY OF THE DESIGN ASSOCIATES INC. AND SHALL NOT BE COPIED OR USED IN ANY MANNER WITHOUT PRIOR PERMISSION.

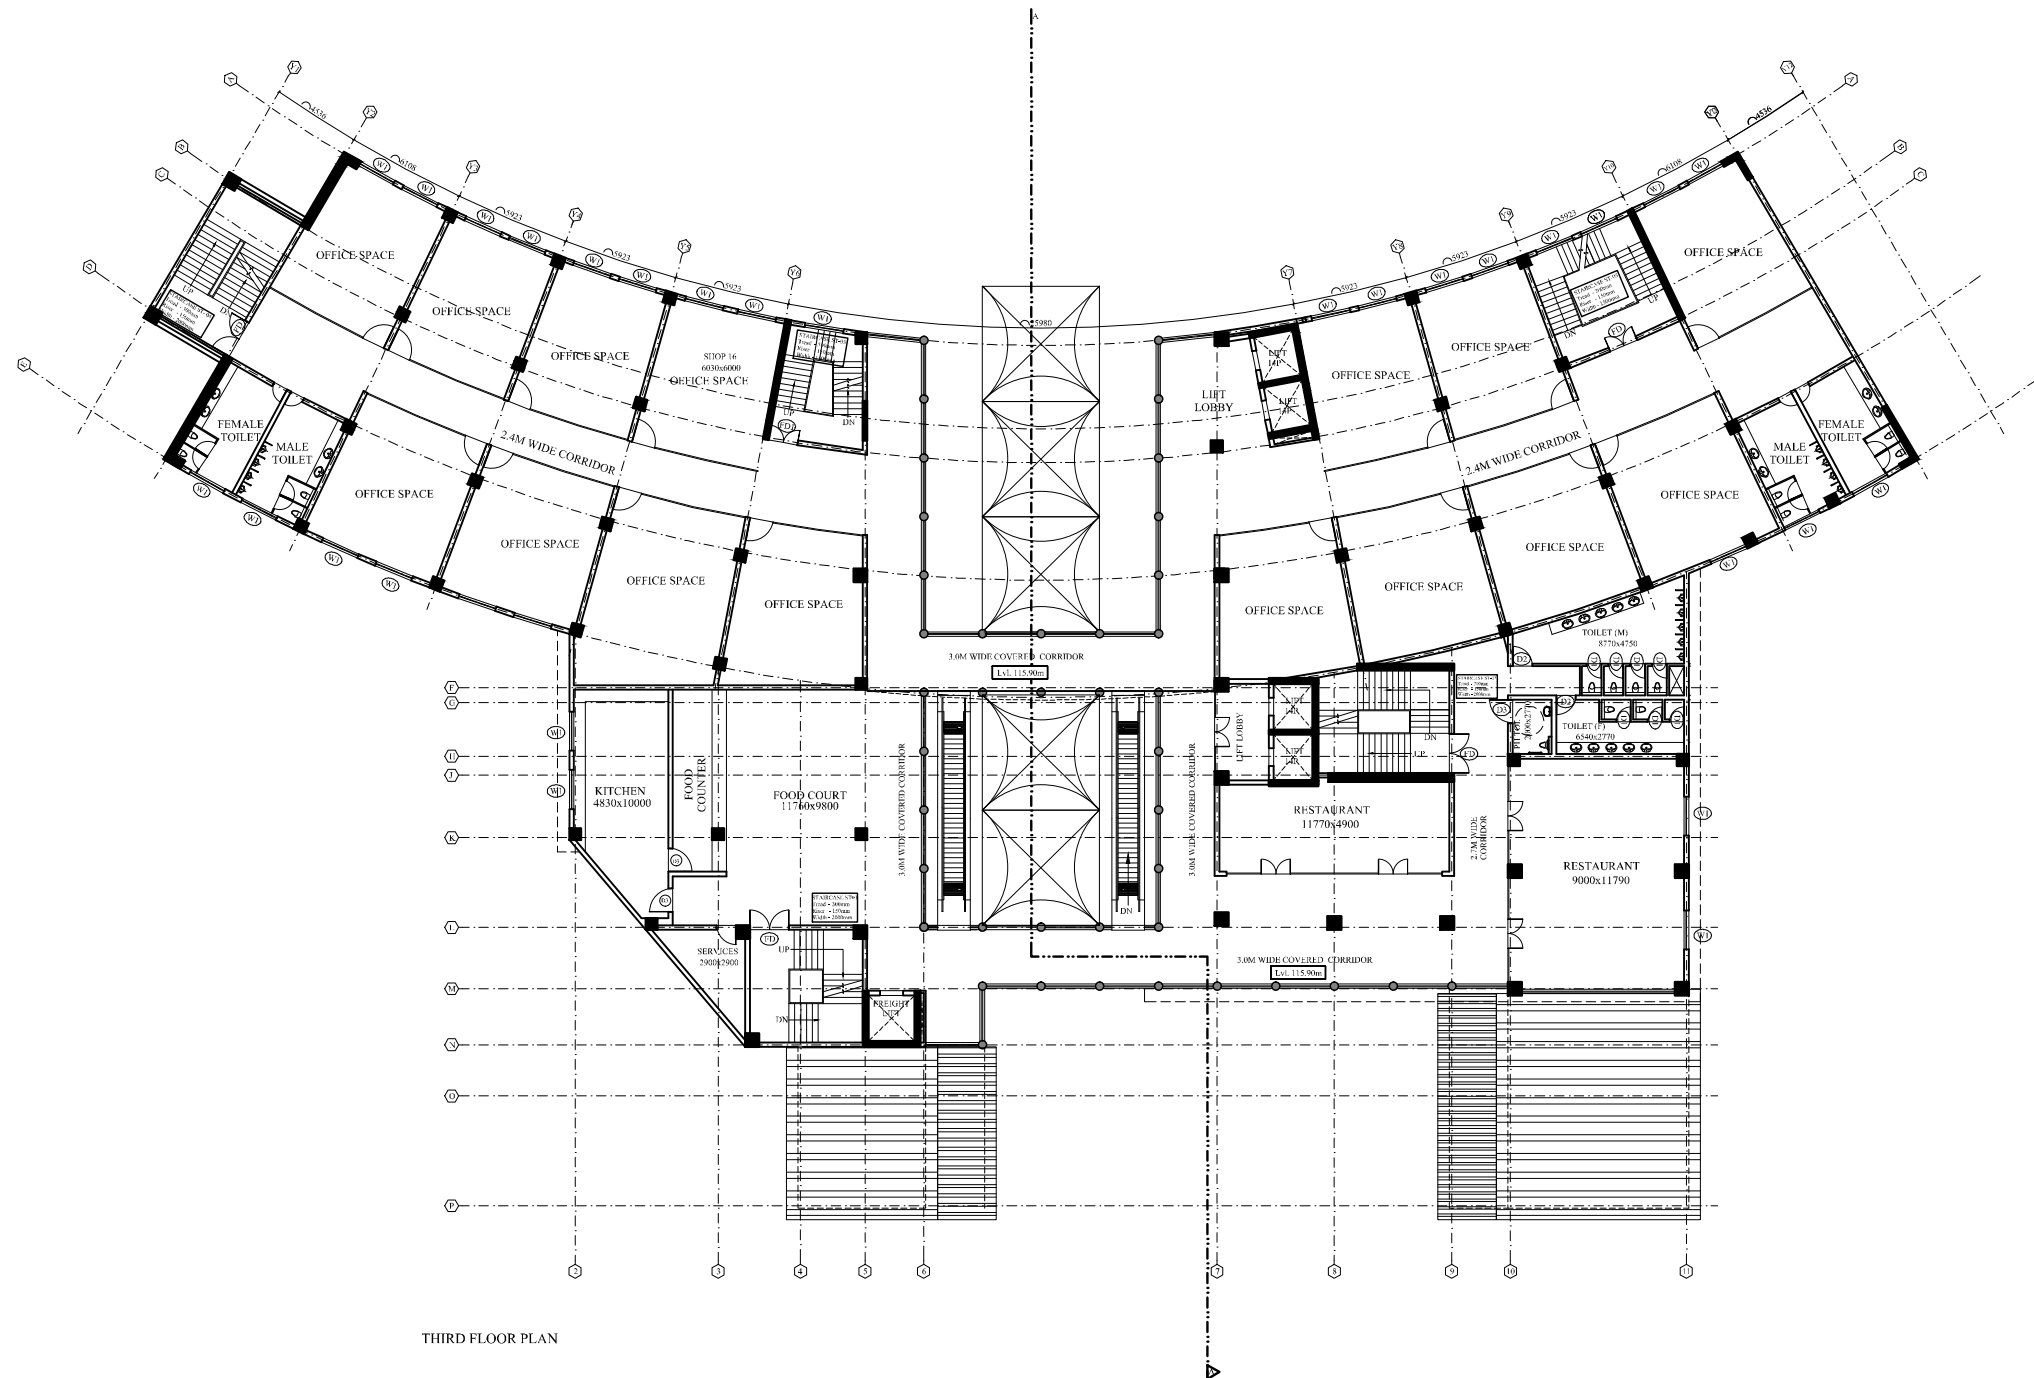

THIRD FLOOR PLAN

- NOTES:-
1. ALL DIMENSIONS ARE IN MM.
 2. ALL DIMENSIONS ARE TO BE READ AND NOT MEASURED.
 3. ALL LEVELS ARE IN MM.
 4. GRID DIMENSIONS AND PLOT LINES ARE TO BE STRICTLY ADHERED TO.
 5. ALL LEVELS INCLUDING FLOOR LEVELS, CILL & LINTEL LEVELS, LANDING LEVELS, PARAPET HEIGHT, LEVELS, LEVELS OF HORIZONTAL PROJECTION & BONDS INCLUDING ANY SURFACE FEATURES INDICATED IN THE DRAWINGS ARE TO BE STRICTLY ADHERED TO.

MARK	DATE	DESCRIPTION

MECHANICAL CONSULTANT:-
ARK CONSULTANTS
NEW DELHI

ELECTRICAL CONSULTANT:-
ARK CONSULTANTS
NEW DELHI

PLUMBING CONSULTANT:-
ARK CONSULTANTS
NEW DELHI

STRUCTURE CONSULTANT:-
CE CON ENGG.
NEW DELHI

ARCHITECTS:-



A-163, Sector-136, Noida 201301
PH. :0120-2428600, Fax: 0120-4778530
e-mail: sachin.agarwal@designassociates.in

PROJECT-

COMMERCIAL COMPLEX
AT POLO MARKET
SHILLONG

DRAWING TITLE-

THIRD FLOOR PLAN

DRAWING PURPOSE-

FOR TENDER PURPOSES ONLY

JOB NO. - ---	DWG. REF. NO. - ---	DATE - 30.08.2018
SCALE - 1:100	REVISION - ---	DATE OF ISSUE - ---


DWG. NO. -

PM/CD/AR/105

SHEET SIZE - A3	SHEET NO. - 01/01
DRAWN BY - --	CHECKED BY - SACHIN



THIS DRAWING IS THE PROPERTY OF THE DESIGN ASSOCIATES INC. AND SHALL NOT BE COPIED OR USED IN ANY MANNER WITHOUT PRIOR PERMISSION.

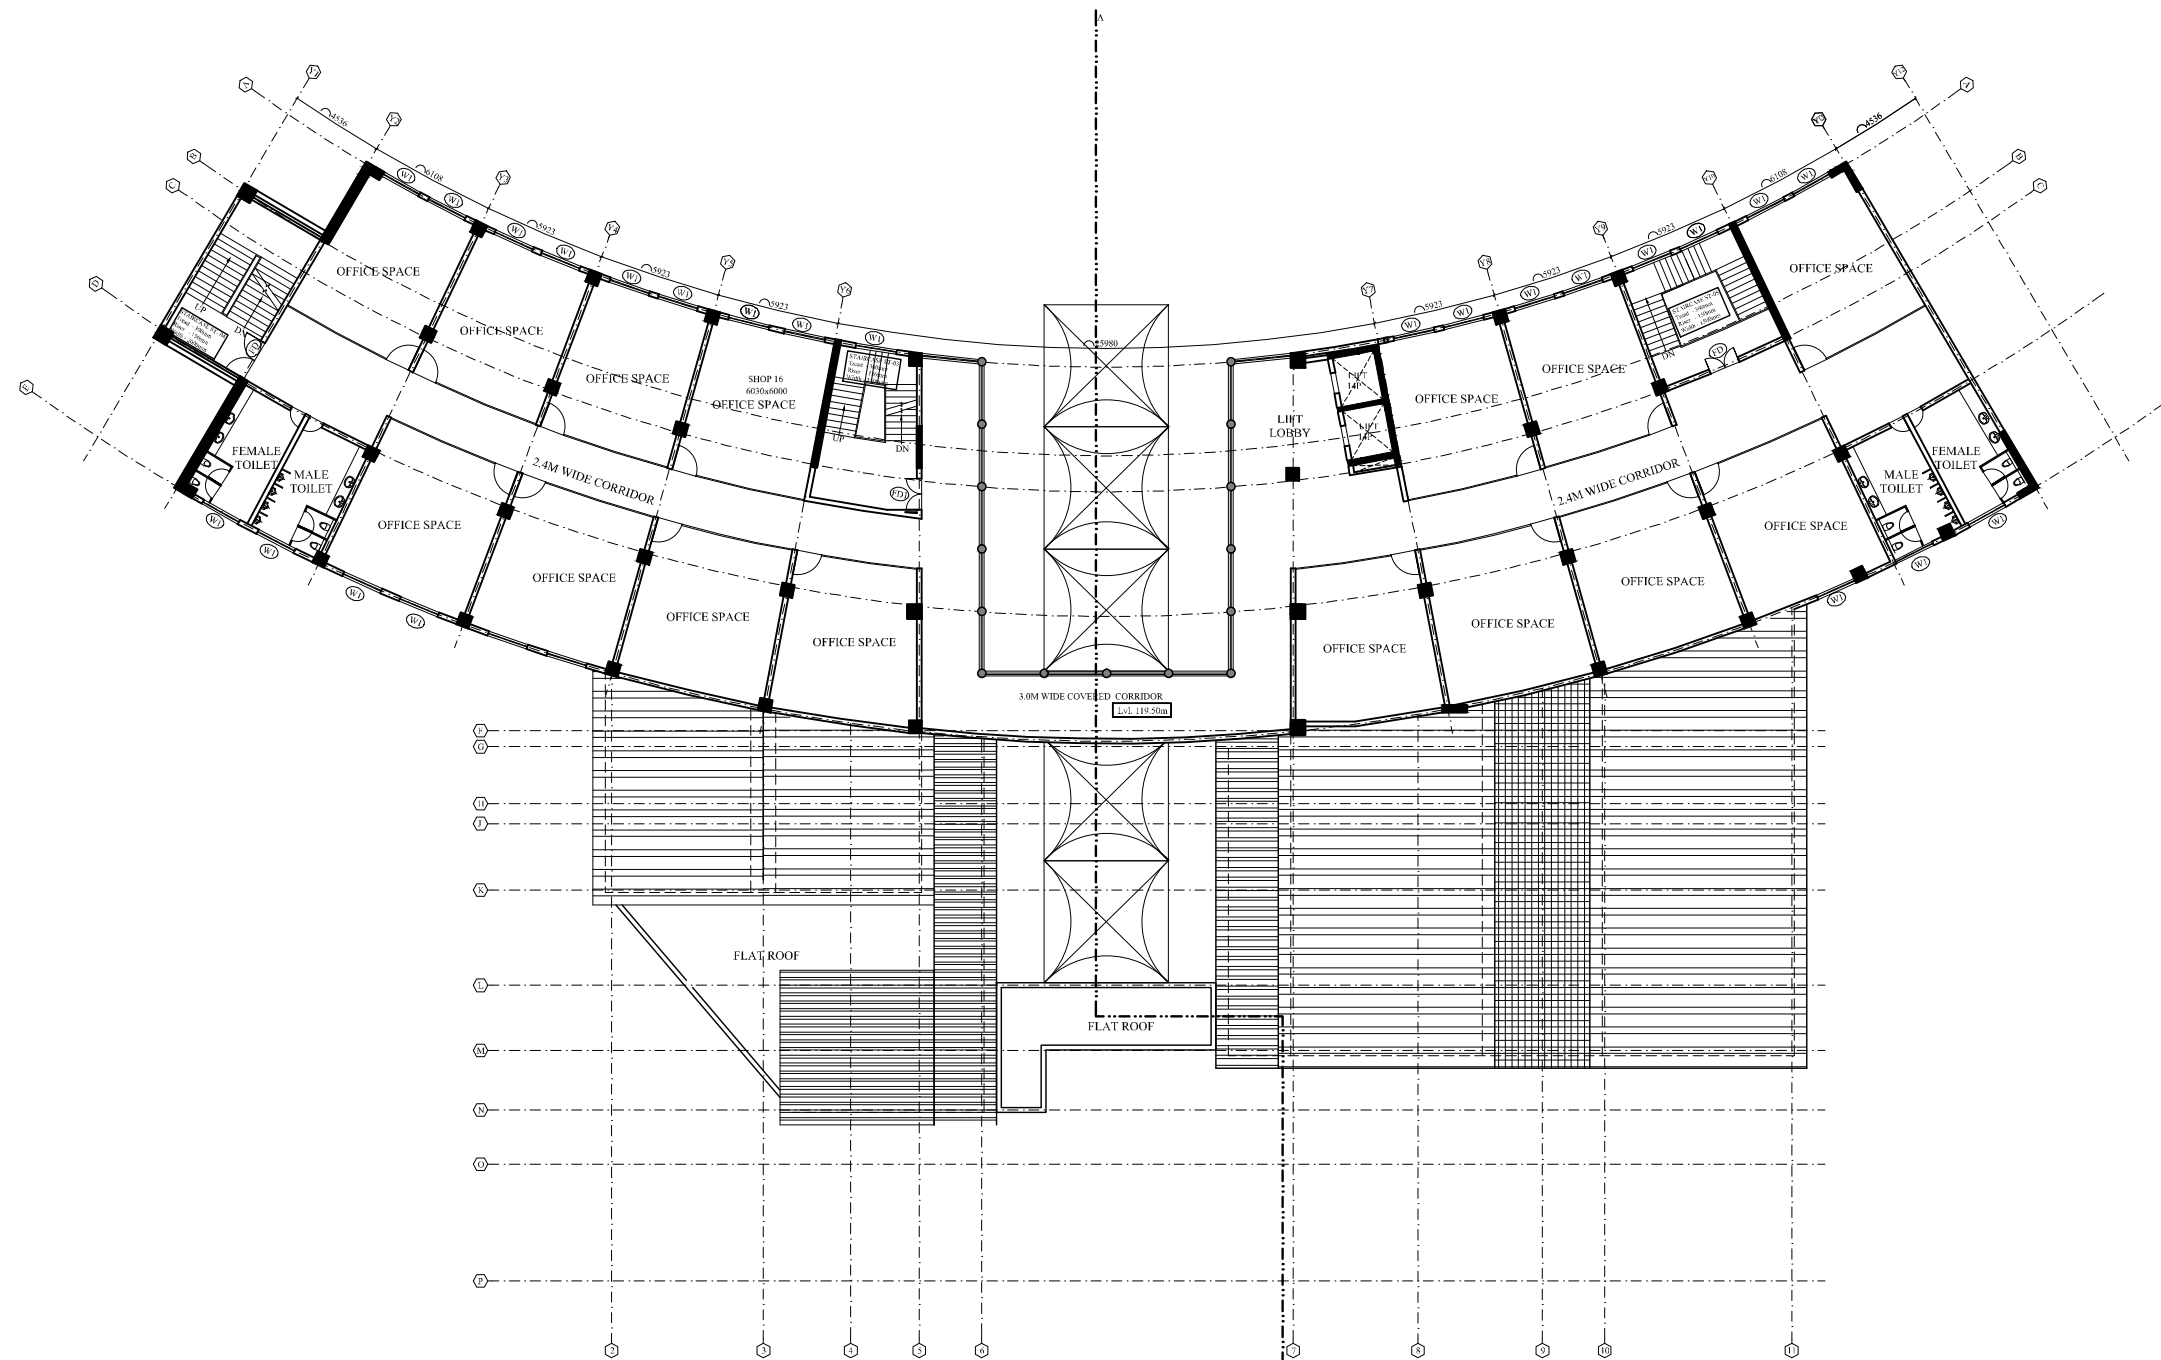

FOURTH FLOOR PLAN

- NOTES:-
1. ALL DIMENSIONS ARE IN MM.
 2. ALL DIMENSIONS ARE TO BE READ AND NOT MEASURED.
 3. ALL LEVELS ARE IN MM.
 4. GRID DIMENSIONS AND PLOT LINES ARE TO BE STRICTLY ADHERED TO.
 5. ALL LEVELS INCLUDING FLOOR LEVELS, CILL & LINTEL LEVELS, LANDING LEVELS, PARAPET HEIGHT/ LEVELS, LEVELS OF HORIZONTAL PROJECTION & BONDS INCLUDING ANY SURFACE FEATURES INDICATED IN THE DRAWINGS ARE TO BE STRICTLY ADHERED TO.

MARK	DATE	DESCRIPTION

MECHANICAL CONSULTANT-
ARK CONSULTANTS
NEW DELHI

ELECTRICAL CONSULTANT-
ARK CONSULTANTS
NEW DELHI

PLUMBING CONSULTANT-
ARK CONSULTANTS
NEW DELHI

STRUCTURE CONSULTANT-
CE CON ENGG.
NEW DELHI

ARCHITECTS-
DESIGN ASSOCIATES INC.
ARCHITECTURE

A-163, Sector-136, Noida 201301
PH. :0120-2428600, Fax: 0120-4778530
e-mail: sachin.agarwal@designassociates.in

PROJECT-
COMMERCIAL COMPLEX
AT POLO MARKET
SHILLONG

DRAWING TITLE-
FOURTH FLOOR PLAN

DRAWING PURPOSE-
FOR TENDER PURPOSES ONLY

JOB NO. - ---	DWG. REF. NO. - ---	DATE - 30.08.2018
SCALE - 1:100	REVISION - ---	DATE OF ISSUE - ---

DWG. NO. -
PM/CD/AR/106

SHEET SIZE - A3	SHEET NO. - 01/01
DRAWN BY - --	CHECKED BY - SACHIN



THIS DRAWING IS THE PROPERTY OF THE DESIGN ASSOCIATES INC. AND SHALL NOT BE COPIED OR USED IN ANY MANNER WITHOUT PRIOR PERMISSION.

NOTES:-

1. ALL DIMENSIONS ARE IN MM.
2. ALL DIMENSIONS ARE TO BE READ AND NOT MEASURED.
3. ALL LEVELS ARE IN MM.
4. GRID DIMENSIONS AND PLOT LINES ARE TO BE STRICTLY ADHERED TO.
5. ALL LEVELS INCLUDING FLOOR LEVELS, CHL & LINTEL LEVELS, LANDING LEVELS, PARAPET HEIGHT LEVELS, LEVELS OF HORIZONTAL PROJECTION & BONDS INCLUDING ANY SURFACE FEATURES INDICATED IN THE DRAWINGS ARE TO BE STRICTLY ADHERED TO.

MARK	DATE	DESCRIPTION

MECHANICAL CONSULTANT-

ARK CONSULTANTS
NEW DELHI

ELECTRICAL CONSULTANT-

ARK CONSULTANTS
NEW DELHI

PLUMBING CONSULTANT-

ARK CONSULTANTS
NEW DELHI

STRUCTURE CONSULTANT-

CE CON ENGG.
NEW DELHI

ARCHITECTS-

DESIGN ASSOCIATES INC.
ARCHITECTS

A-163, Sector-136, Noida 201301
PH. 0120-2428600, Fax: 0120-4778530
e-mail: sachin.agarwal@designassociates.in

PROJECT-

COMMERCIAL COMPLEX
AT POLO MARKET
SHILLONG

DRAWING TITLE-

CROSS SECTION A-A

DRAWING PURPOSE-

FOR TENDER PURPOSES ONLY

JOB NO. - DWG. REF. NO. - DATE-

--- --- 30.08.2018

SCALE- REVISION- DATE OF ISSUE-

1:200 --- ---

DWG. NO. -


PM/CD/AR/201

SHEET SIZE- SHEET NO-

A3 01/01

DRAWN BY- CHECKED BY-

-- SACHIN

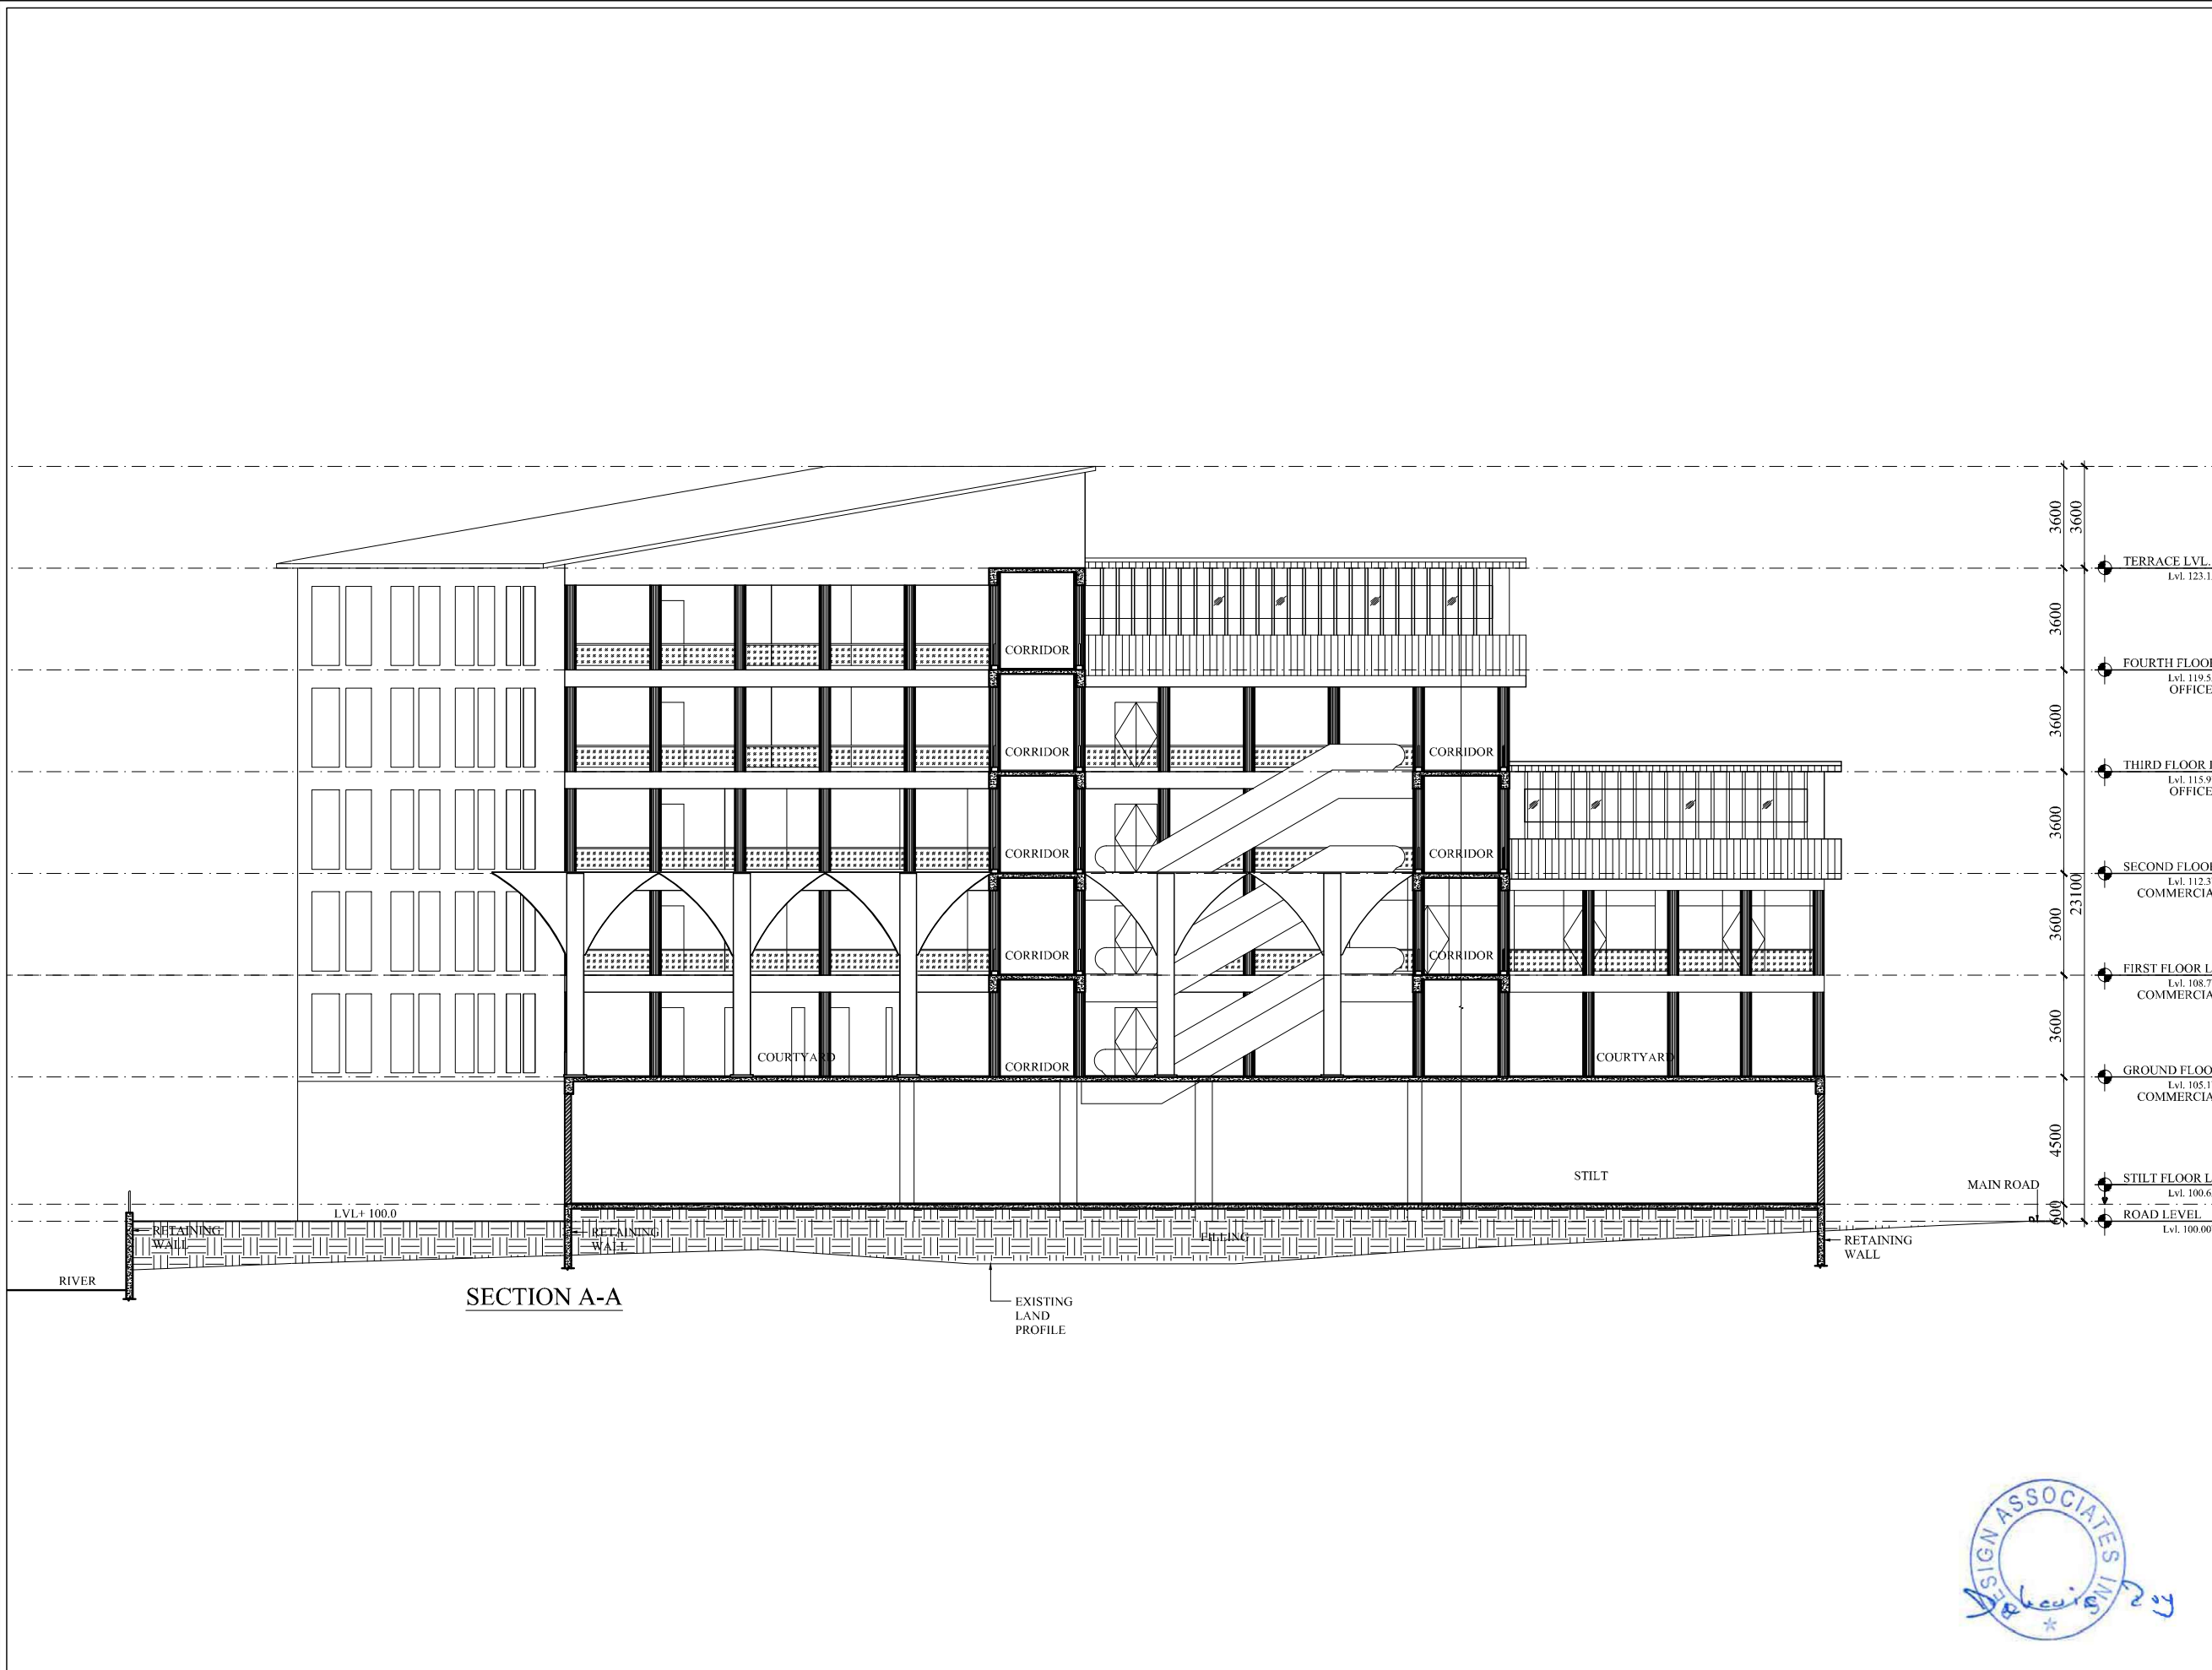

THIS DRAWING IS THE PROPERTY OF THE DESIGN ASSOCIATES INC. AND SHALL NOT BE COPIED OR USED IN ANY MANNER WITHOUT PRIOR PERMISSION.

NOTES:-

1. ALL DIMENSIONS ARE IN MM.
2. ALL DIMENSIONS ARE TO BE READ AND NOT MEASURED.
3. ALL LEVELS ARE IN MM.
4. GRID DIMENSIONS AND PLOT LINES ARE TO BE STRICTLY ADHERED TO.
5. ALL LEVELS INCLUDING FLOOR LEVELS, CILL & LINTEL LEVELS, LANDING LEVELS, PARAPET HEIGHT/ LEVELS, LEVELS OF HORIZONTAL PROJECTION & BONDS INCLUDING ANY SURFACE FEATURES INDICATED IN THE DRAWINGS ARE TO BE STRICTLY ADHERED TO.

MARK	DATE	DESCRIPTION

MECHANICAL CONSULTANT-
ARK CONSULTANTS
NEW DELHI

ELECTRICAL CONSULTANT-
ARK CONSULTANTS
NEW DELHI

PLUMBING CONSULTANT-
ARK CONSULTANTS
NEW DELHI

STRUCTURE CONSULTANT-
CE CON ENGG.
NEW DELHI

ARCHITECTS-
DESIGN ASSOCIATES INC.
ARCHITECTURE
A-163, Sector-136, Noida 201301
PH. :0120-2428600, Fax: 0120-4778530
e-mail: sachin.agarwal@designassociates.in


PROJECT-
COMMERCIAL COMPLEX
AT POLO MARKET
SHILLONG

DRAWING TITLE-
VIEW-01

DRAWING PURPOSE-
FOR TENDER PURPOSES ONLY

JOB NO. - ---	DWG. REF. NO.- ---	DATE- 30.08.2018
SCALE- 1:200	REVISION- ---	DATE OF ISSUE- ---

DWG. NO.-
PM/TD/AR/001

	SHEET SIZE- A3	SHEET NO- 01/01
	DRAWN BY- ABRAR	CHECKED BY- SACHIN





THIS DRAWING IS THE PROPERTY OF THE DESIGN ASSOCIATES INC. AND SHALL NOT BE COPIED OR USED IN ANY MANNER WITHOUT PRIOR PERMISSION.

NOTES:-

1. ALL DIMENSIONS ARE IN MM.
2. ALL DIMENSIONS ARE TO BE READ AND NOT MEASURED.
3. ALL LEVELS ARE IN MM.
4. GRID DIMENSIONS AND PLOT LINES ARE TO BE STRICTLY ADHERED TO.
5. ALL LEVELS INCLUDING FLOOR LEVELS, CILL & LINTEL LEVELS, LANDING LEVELS, PARAPET HEIGHT/ LEVELS, LEVELS OF HORIZONTAL PROJECTION & BONDS INCLUDING ANY SURFACE FEATURES INDICATED IN THE DRAWINGS ARE TO BE STRICTLY ADHERED TO.

MARK	DATE	DESCRIPTION

MECHANICAL CONSULTANT-

ARK CONSULTANTS
NEW DELHI

ELECTRICAL CONSULTANT-

ARK CONSULTANTS
NEW DELHI

PLUMBING CONSULTANT-

ARK CONSULTANTS
NEW DELHI

STRUCTURE CONSULTANT-

CE CON ENGG.
NEW DELHI

ARCHITECTS-

DESIGN ASSOCIATES INC.
ARCHITECTURE

A-163, Sector-136, Noida 201301
PH. :0120-2428600, Fax: 0120-4778530
e-mail: sachin.agarwal@designassociates.in

PROJECT-

COMMERCIAL COMPLEX
AT POLO MARKET
SHILLONG

DRAWING TITLE-

VIEW-02

DRAWING PURPOSE-

FOR TENDER PURPOSES ONLY

JOB NO. - ---	DWG. REF. NO.- ----	DATE- 30.08.2018
------------------	------------------------	---------------------

SCALE- 1:200	REVISION- ----	DATE OF ISSUE- ----
-----------------	-------------------	------------------------

DWG. NO.- PM/TD/AR/002		
---------------------------	--	--

	SHEET SIZE- A3	SHEET NO- 01/01
	DRAWN BY- ABRAR	CHECKED BY- SACHIN





THIS DRAWING IS THE PROPERTY OF THE DESIGN ASSOCIATES INC. AND SHALL NOT BE COPIED OR USED IN ANY MANNER WITHOUT PRIOR PERMISSION.

NOTES:-

1. ALL DIMENSIONS ARE IN MM.
2. ALL DIMENSIONS ARE TO BE READ AND NOT MEASURED.
3. ALL LEVELS ARE IN MM.
4. GRID DIMENSIONS AND PLOT LINES ARE TO BE STRICTLY ADHERED TO.
5. ALL LEVELS INCLUDING FLOOR LEVELS, CILL & LINTEL LEVELS, LANDING LEVELS, PARAPET HEIGHT/ LEVELS, LEVELS OF HORIZONTAL PROJECTION & BONDS INCLUDING ANY SURFACE FEATURES INDICATED IN THE DRAWINGS ARE TO BE STRICTLY ADHERED TO.

MARK	DATE	DESCRIPTION

MECHANICAL CONSULTANT-
ARK CONSULTANTS
NEW DELHI

ELECTRICAL CONSULTANT-
ARK CONSULTANTS
NEW DELHI

PLUMBING CONSULTANT-
ARK CONSULTANTS
NEW DELHI

STRUCTURE CONSULTANT-
CE CON ENGG.
NEW DELHI

ARCHITECTS-
DESIGN ASSOCIATES INC.
ARCHITECTURE
A-163, Sector-136, Noida 201301
PH. :0120-2428600, Fax: 0120-4778530
e-mail: sachin.agarwal@designassociates.in

PROJECT-
COMMERCIAL COMPLEX
AT POLO MARKET
SHILLONG

DRAWING TITLE-
VIEW-03

DRAWING PURPOSE-
FOR TENDER PURPOSES ONLY

JOB NO. - ---	DWG. REF. NO.- ---	DATE- 30.08.2018
------------------	-----------------------	---------------------

SCALE- 1:200	REVISION- ---	DATE OF ISSUE- ---
-----------------	------------------	-----------------------

DWG. NO.-
PM/TD/AR/003

	SHEET SIZE- A3	SHEET NO- 01/01
	DRAWN BY- ABRAR	CHECKED BY- SACHIN





THIS DRAWING IS THE PROPERTY OF THE DESIGN ASSOCIATES INC. AND SHALL NOT BE COPIED OR USED IN ANY MANNER WITHOUT PRIOR PERMISSION.

NOTES:-

1. ALL DIMENSIONS ARE IN MM.
2. ALL DIMENSIONS ARE TO BE READ AND NOT MEASURED.
3. ALL LEVELS ARE IN MM.
4. GRID DIMENSIONS AND PLOT LINES ARE TO BE STRICTLY ADHERED TO.
5. ALL LEVELS INCLUDING FLOOR LEVELS, CILL & LINTEL LEVELS, LANDING LEVELS, PARAPET HEIGHT/ LEVELS, LEVELS OF HORIZONTAL PROJECTION & BONDS INCLUDING ANY SURFACE FEATURES INDICATED IN THE DRAWINGS ARE TO BE STRICTLY ADHERED TO.

MARK	DATE	DESCRIPTION

MECHANICAL CONSULTANT-
ARK CONSULTANTS
NEW DELHI

ELECTRICAL CONSULTANT-
ARK CONSULTANTS
NEW DELHI

PLUMBING CONSULTANT-
ARK CONSULTANTS
NEW DELHI

STRUCTURE CONSULTANT-
CE CON ENGG.
NEW DELHI

ARCHITECTS-
DESIGN ASSOCIATES INC.
ARCHITECTURE
A-163, Sector-136, Noida 201301
PH. :0120-2428600, Fax: 0120-4778530
e-mail: sachin.agarwal@designassociates.in

PROJECT-
COMMERCIAL COMPLEX
AT POLO MARKET
SHILLONG

DRAWING TITLE-
VIEW-04

DRAWING PURPOSE-
FOR TENDER PURPOSES ONLY

JOB NO. - ---	DWG. REF. NO.- ---	DATE- 30.08.2018
------------------	-----------------------	---------------------

SCALE- 1:200	REVISION- ---	DATE OF ISSUE- ---
-----------------	------------------	-----------------------

DWG. NO.-
PM/TD/AR/004

	SHEET SIZE- A3	SHEET NO- 01/01
	DRAWN BY- ABRAR	CHECKED BY- SACHIN





THIS DRAWING IS THE PROPERTY OF THE DESIGN ASSOCIATES INC. AND SHALL NOT BE COPIED OR USED IN ANY MANNER WITHOUT PRIOR PERMISSION.

NOTES:-

1. ALL DIMENSIONS ARE IN MM.
2. ALL DIMENSIONS ARE TO BE READ AND NOT MEASURED.
3. ALL LEVELS ARE IN MM.
4. GRID DIMENSIONS AND PLOT LINES ARE TO BE STRICTLY ADHERED TO.
5. ALL LEVELS INCLUDING FLOOR LEVELS, CILL & LINTEL LEVELS, LANDING LEVELS, PARAPET HEIGHT/ LEVELS, LEVELS OF HORIZONTAL PROJECTION & BONDS INCLUDING ANY SURFACE FEATURES INDICATED IN THE DRAWINGS ARE TO BE STRICTLY ADHERED TO.

MARK	DATE	DESCRIPTION

MECHANICAL CONSULTANT-
ARK CONSULTANTS
NEW DELHI

ELECTRICAL CONSULTANT-
ARK CONSULTANTS
NEW DELHI

PLUMBING CONSULTANT-
ARK CONSULTANTS
NEW DELHI

STRUCTURE CONSULTANT-
CE CON ENGG.
NEW DELHI

ARCHITECTS-
DESIGN ASSOCIATES INC.
ARCHITECTURE
A-163, Sector-136, Noida 201301
PH. :0120-2428600, Fax: 0120-4778530
e-mail: sachin.agarwal@designassociates.in

PROJECT-
**COMMERCIAL COMPLEX
AT POLO MARKET
SHILLONG**

DRAWING TITLE-
VIEW-05

DRAWING PURPOSE-
FOR TENDER PURPOSES ONLY

JOB NO. - ---	DWG. REF. NO.- ----	DATE- 30.08.2018
SCALE- 1:200	REVISION- ----	DATE OF ISSUE- ----

DWG. NO.-
PM/TD/AR/005

	SHEET SIZE- A3	SHEET NO- 01/01
	DRAWN BY- ABRAR	CHECKED BY- SACHIN

