


THIS DRAWING IS THE PROPERTY OF THE DESIGN ASSOCIATES INC. AND SHALL NOT BE COPIED OR USED IN ANY MANNER WITHOUT PRIOR PERMISSION.

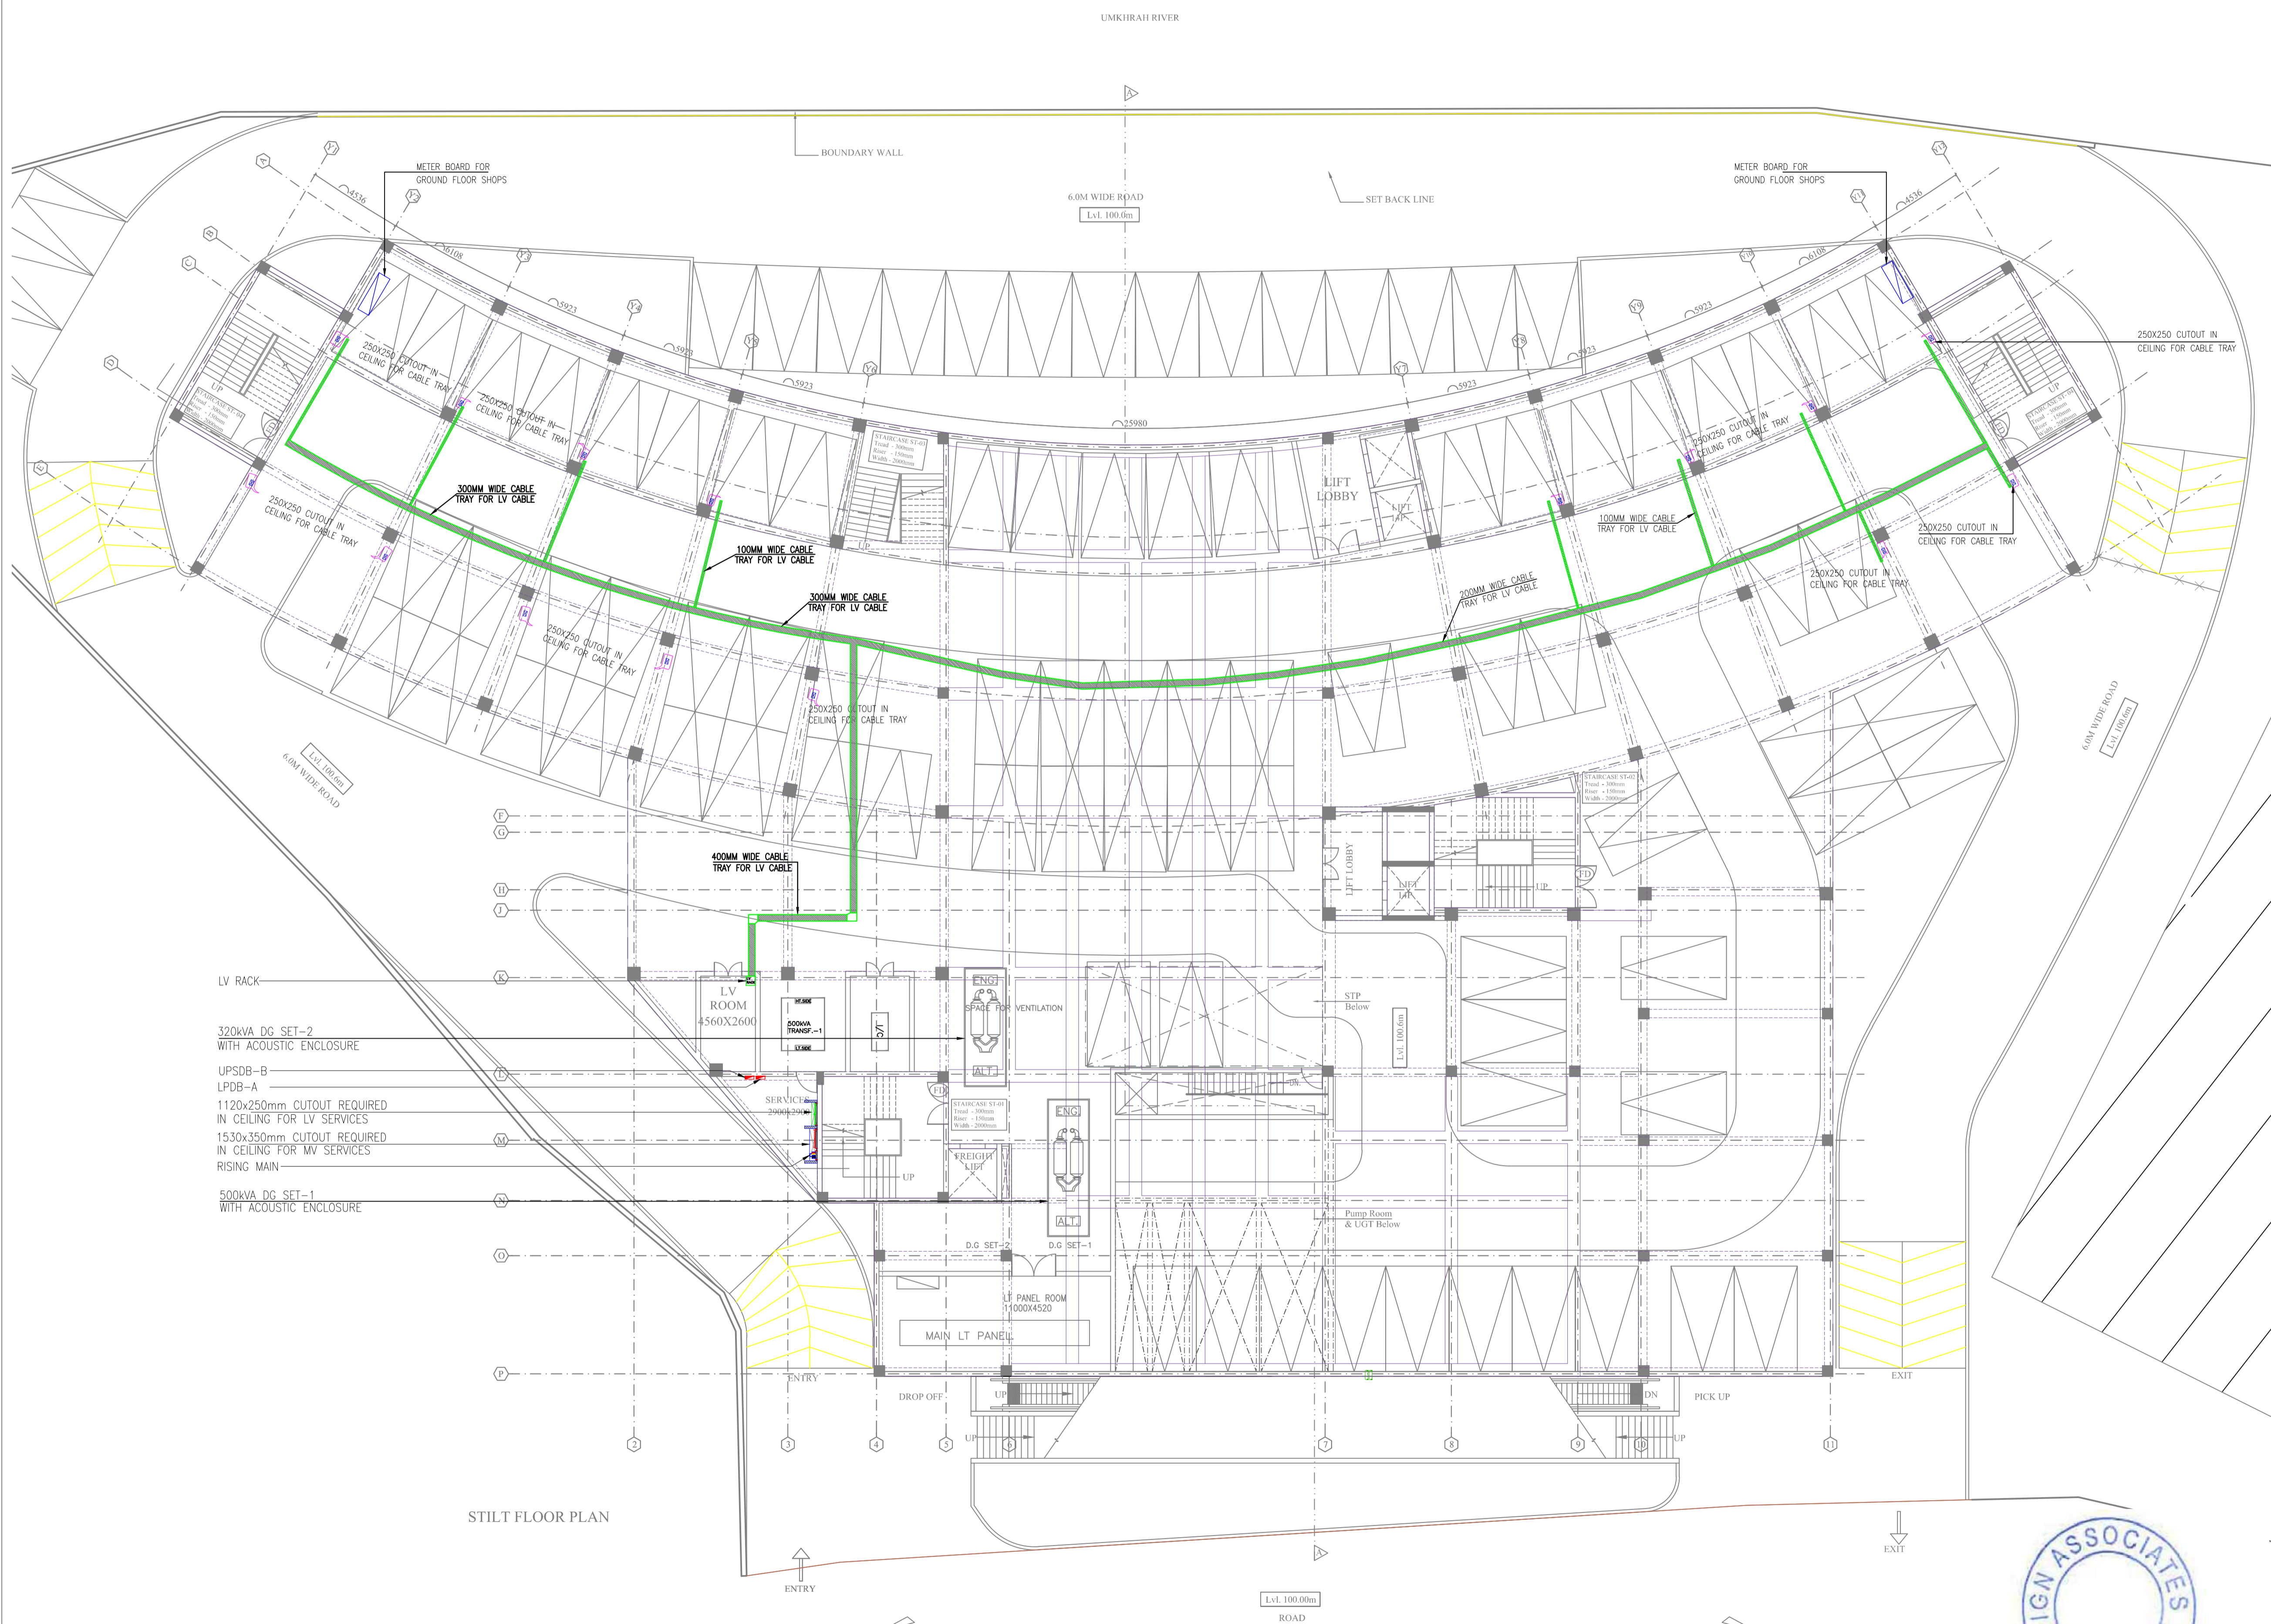

NO. OF PRINTS	DATE	ISSUED TO	REMARKS
REVISION	DATE	DESCRIPTION	BY
R0	28.11.2017	FOR APPROVAL	NIKHIL TYAGI
R1	03.10.2019	FOR APPROVAL	BUNTY

ASSOCIATE ARCHITECTS-  
**DESIGN ASSOCIATES INC.**  
 ARCHITECTURE  
 A - 163, Sector - 136,  
 Noida - Greater Noida Expressway,  
 Noida - 201301  
 Email: sachin.agarwal@designassociates.in

MECHANICAL CONSULTANT-  
 ARK CONSULTANT, NEW DELHI  
 ELECTRICAL CONSULTANT-  
 ARK CONSULTANT, NEW DELHI  
 PLUMBING CONSULTANT-  
 ARK CONSULTANT, NEW DELHI  
 STRUCTURE CONSULTANT-  
 CE CON ENGG., NEW DELHI

PROJECT-  
**COMMERCIAL COMPLEX  
 AT POLO MARKET  
 SHILLONG**

DRAWING TITLE-  
**STILT FLOOR PLAN  
 LV CABLE TRAY LAYOUT**

DRAWING PURPOSE-  
**FOR TENDER PURPOSES ONLY**

JOB NO. -	DWG. REF. NO.-	DATE-
-----	-----	29-12-2017
SCALE-	REVISION-	DATE OF ISSUE-
1:150	R1	04.10.2019

DWG. NO. -	EL-101	
SHEET SIZE-	A1	SHEET NO.-
DRAWN BY-	BUNTY	CHECKED BY-
		PANKAJ



STILT FLOOR PLAN



THIS DRAWING IS THE PROPERTY OF THE DESIGN ASSOCIATES INC. AND SHALL NOT BE COPIED OR USED IN ANY MANNER WITHOUT PRIOR PERMISSION.

**ELECTRICAL LEGEND :-**

SYMBOL	DESCRIPTION
	EMERGENCY SWITCH BOARD
	SWITCH BOARD
	(1x18WATT) LED LIGHT
	(1x18WATT) LED LIGHT FOR EMERGENCY
	(1x28WATT) CEILING TUBE LIGHT
	(2x28WATT) CEILING TUBE LIGHT
	(1x18WATT) WALL MOUNTED LIGHT
	1x20W BULK HEAD LIGHT
	6A SWITCH SOCKET
	6/16A 5PIN SWITCH SOCKET
	6A 5PIN SWITCH SOCKET FOR UPS
	CCTV CAMERA
	DISTRIBUTION BOARD
	25MMØ CONDUIT FOR LIGHT
	25MMØ CONDUIT FOR EMERGENCY
	25MMØ CONDUIT FOR POWER
	25MMØ CONDUIT FOR UPS

NO. OF PRINTS	DATE	ISSUED TO	REMARKS

REVISION	DATE	DESCRIPTION	BY
R0	28.11.2017	FOR APPROVAL	NIKHIL TYAGI
R1	02.01.2018	FOR APPROVAL	NIKHIL TYAGI
R2	31.01.2018	FOR APPROVAL	NIKHIL TYAGI
R3	21.05.2018	FOR APPROVAL	NIKHIL TYAGI
R4	04.10.2019	FOR APPROVAL	BUNTY


ASSOCIATE ARCHITECTS-  
**DESIGN ASSOCIATES INC.**  
 ARCHITECTURE  
 A - 163, Sector - 136,  
 Noida - Greater Noida Expressway,  
 Noida - 201301  
 Email: sachin.agarwal@designassociates.in

MECHANICAL CONSULTANT-  
 ARK CONSULTANT, NEW DELHI  
 ELECTRICAL CONSULTANT-  
 ARK CONSULTANT, NEW DELHI  
 PLUMBING CONSULTANT-  
 ARK CONSULTANT, NEW DELHI  
 STRUCTURE CONSULTANT-  
 CE CON ENGG., NEW DELHI  
 PROJECT-

COMMERCIAL COMPLEX  
 AT POLO MARKET  
 SHILLONG  
 DRAWING TITLE-  
 STILT FLOOR PLAN  
 LIGHTING LAYOUT

DRAWING PURPOSE-  
 FOR TENDER PURPOSES ONLY  
 JOB NO. - DWG. REF. NO. - DATE-  
 29-12-2017  
 SCALE- REVISION- DATE OF ISSUE-  
 1:150 R4 04.10.2019

DWG. NO.- EL-100  
 SHEET SIZE- A1 SHEET NO-  
 DRAWN BY- BUNTY CHECKED BY- PANKAJ

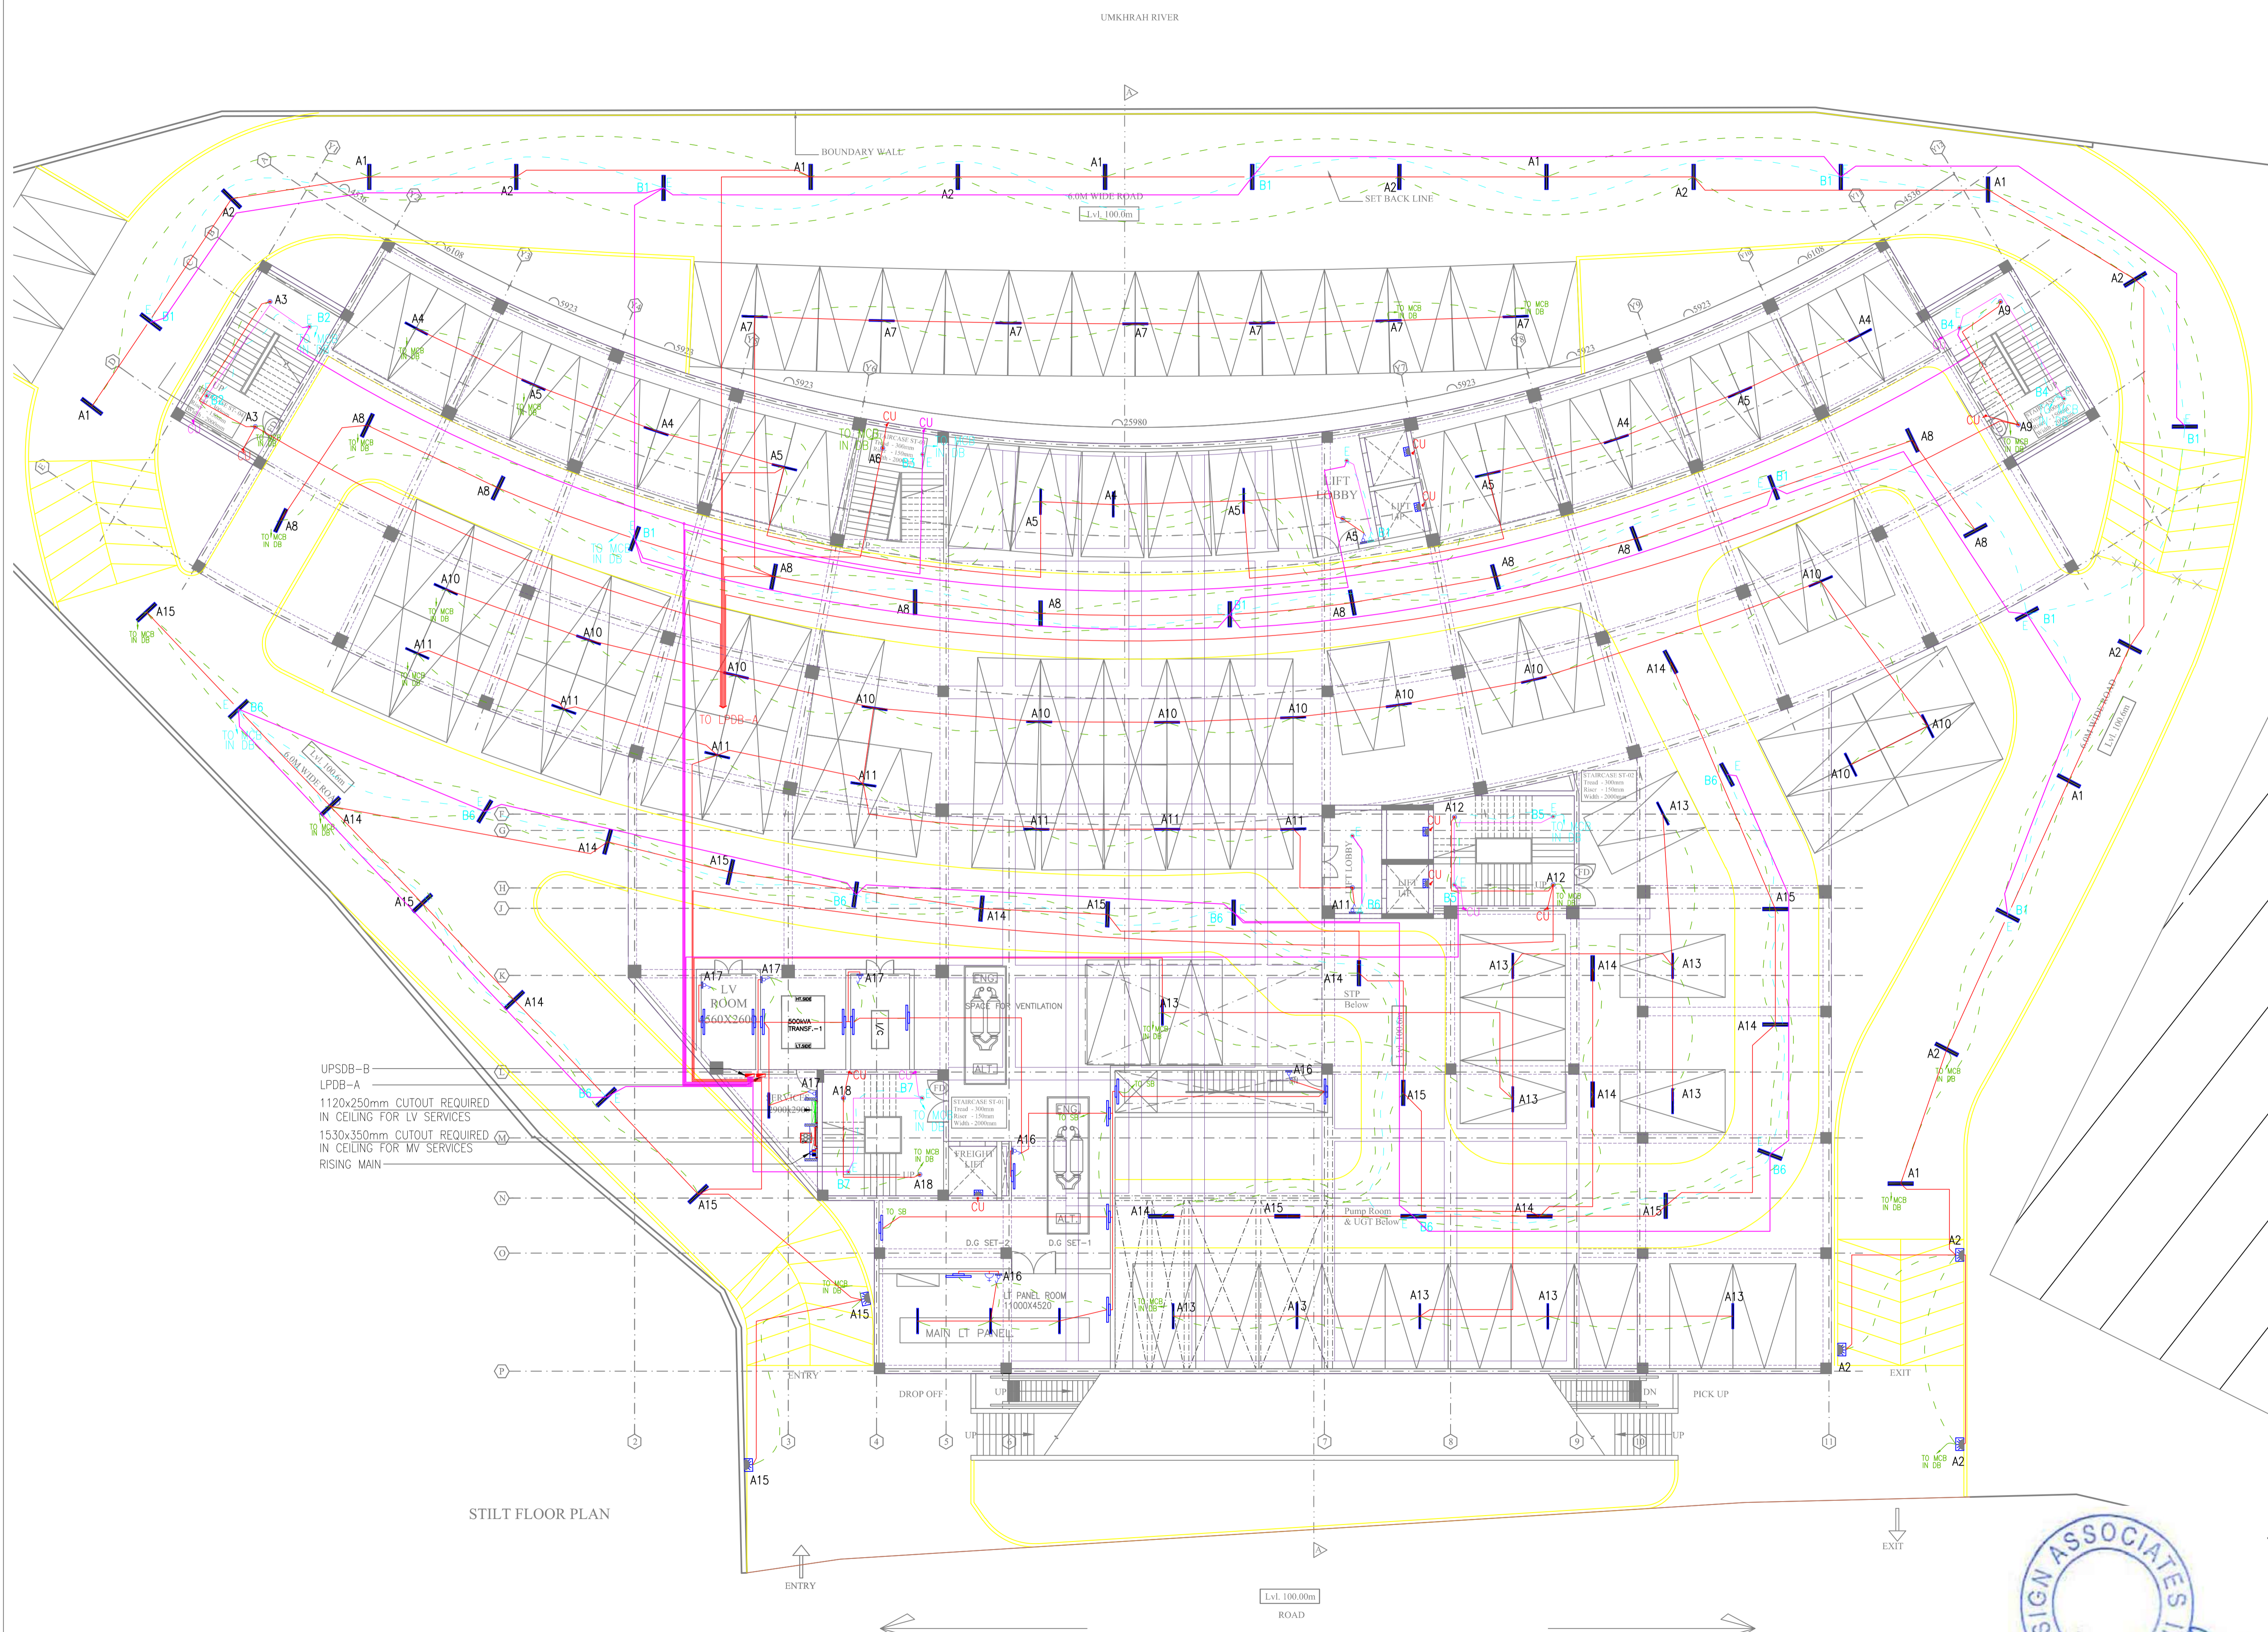
 



STILT FLOOR PLAN



THIS DRAWING IS THE PROPERTY OF THE DESIGN ASSOCIATES INC. AND SHALL NOT BE COPIED OR USED IN ANY MANNER WITHOUT PRIOR PERMISSION.

**ELECTRICAL LEGEND :-**

SYMBOL	DESCRIPTION
	LV CABLE TRAY LAYOUT
	MV CABLE TRAY LAYOUT

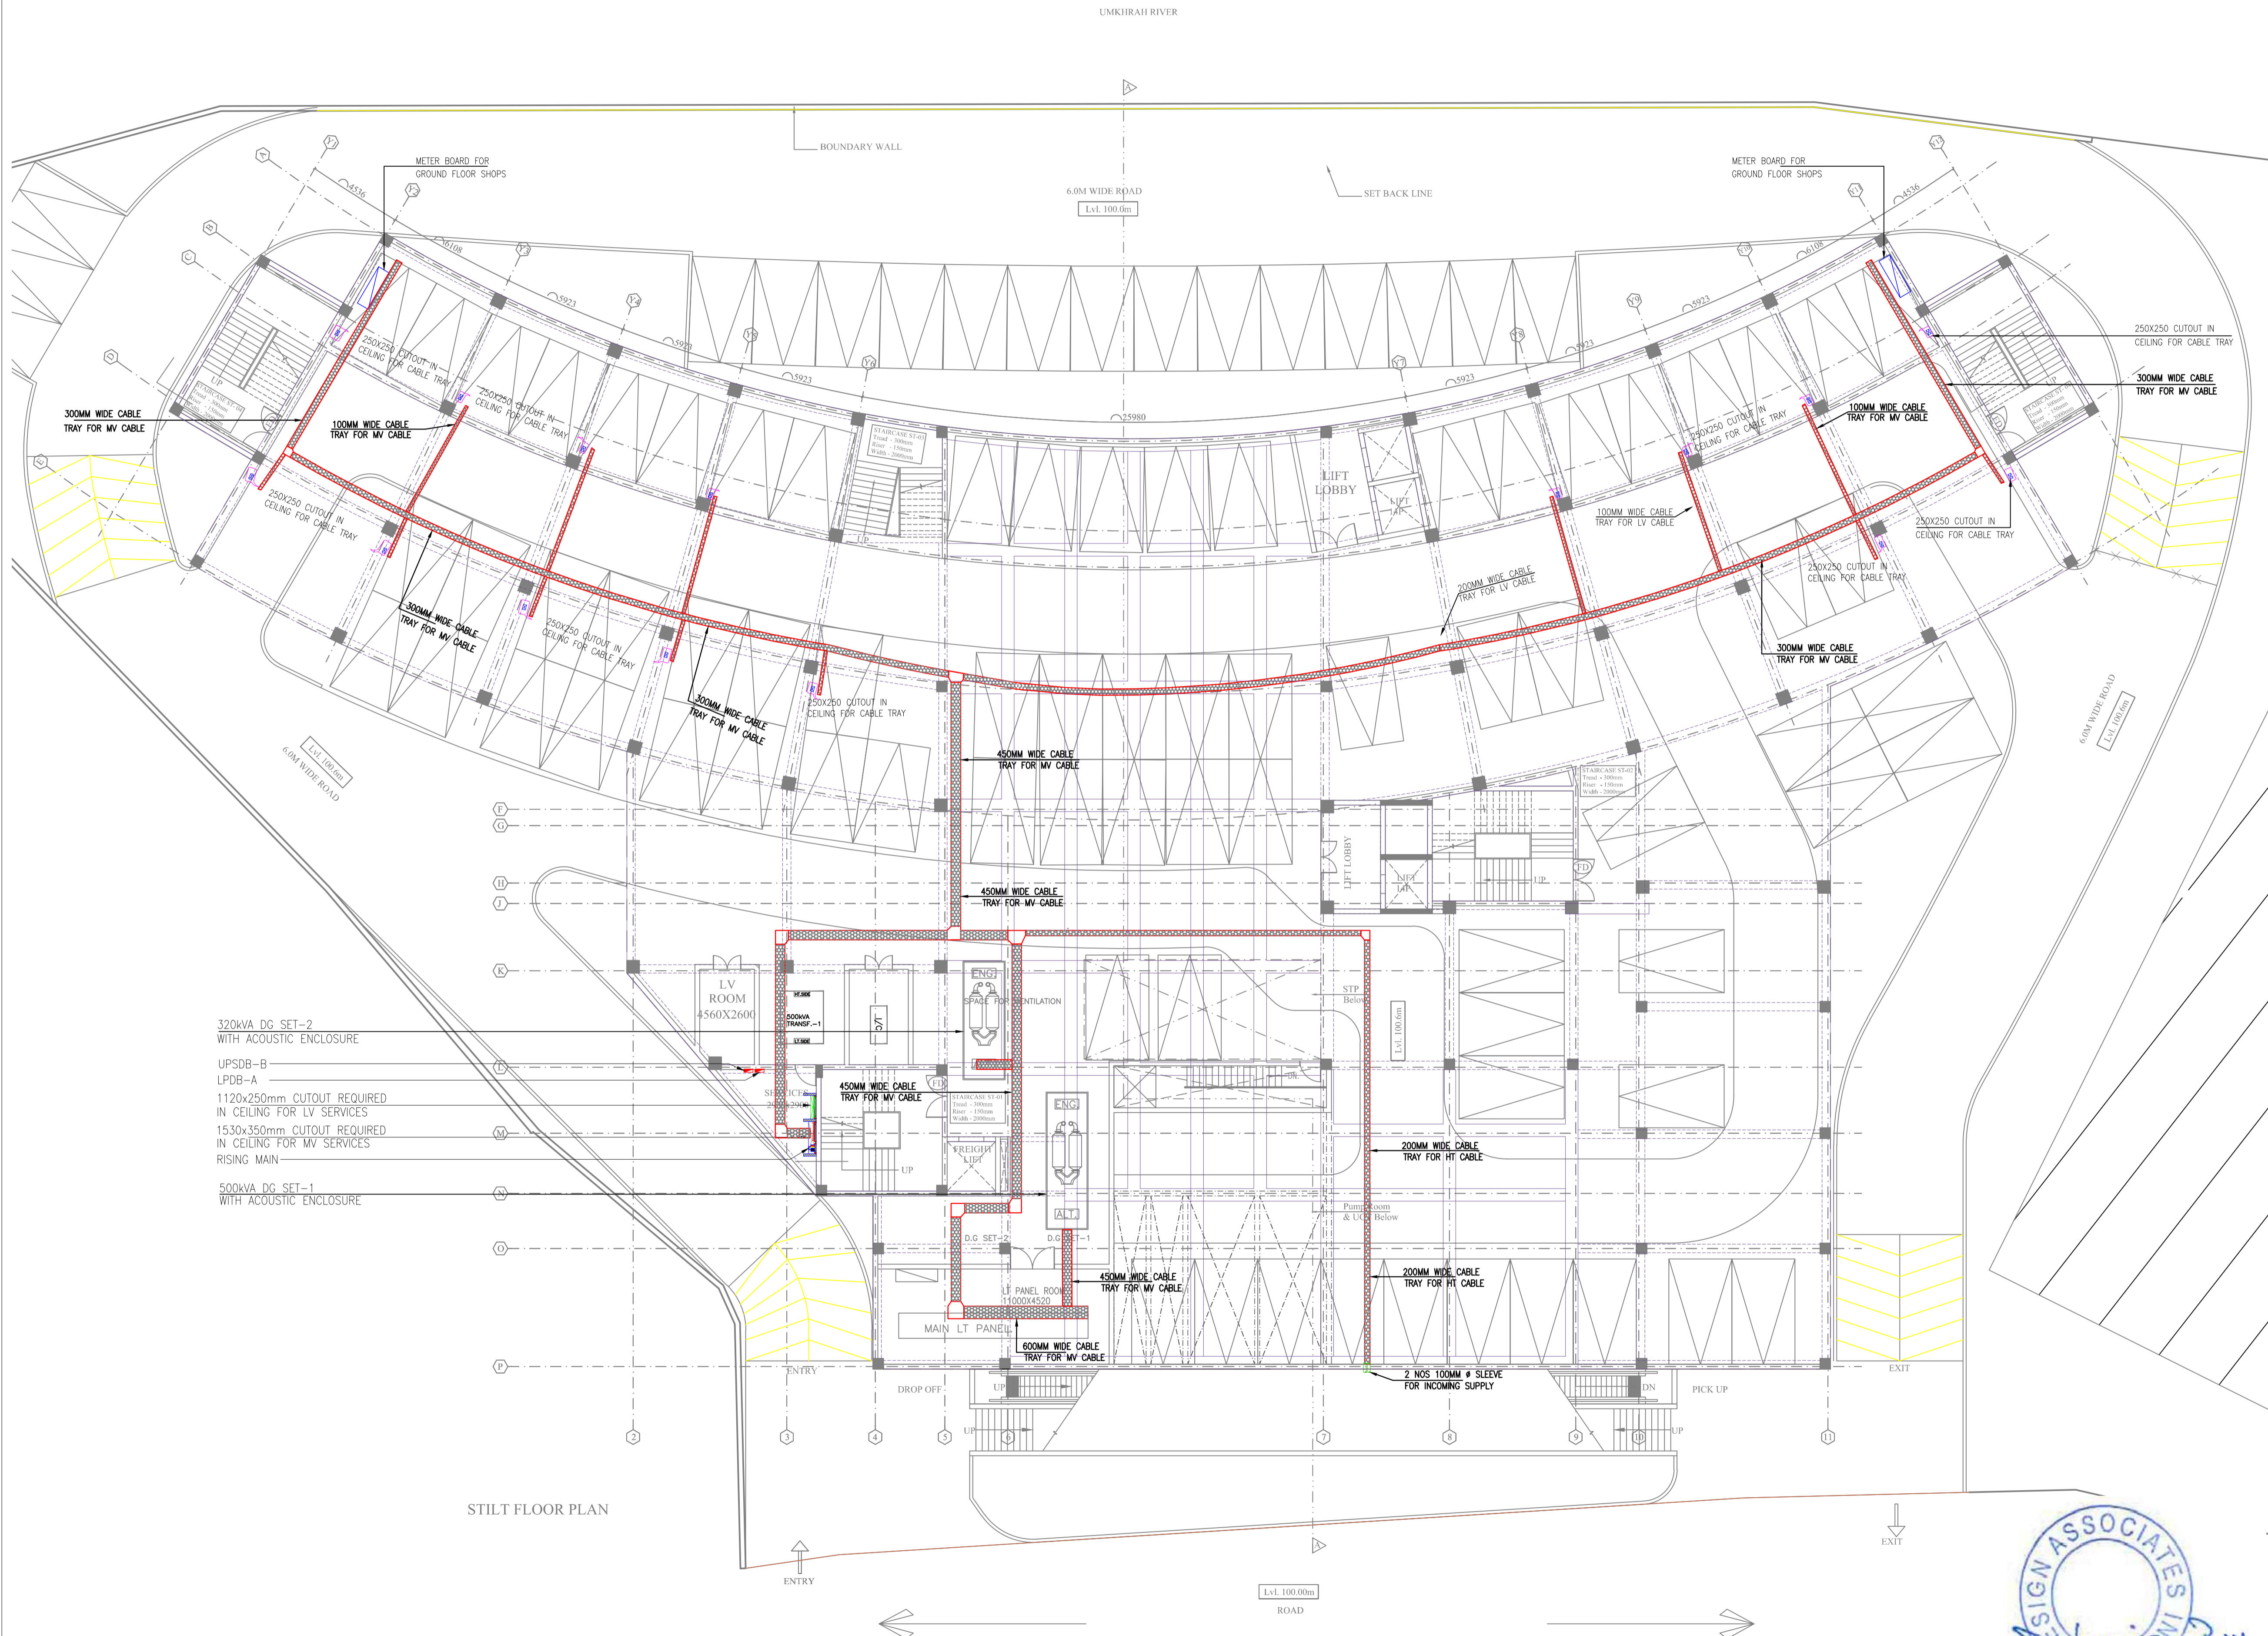

NO. OF PRINTS	DATE	ISSUED TO	REMARKS
REVISION	DATE	DESCRIPTION	BY
R0	28.11.2017	FOR APPROVAL	NIKHIL TYAGI
R1	03.10.2019	FOR APPROVAL	BUNTY

ASSOCIATE ARCHITECTS-  
**DESIGN ASSOCIATES INC.**  
 ARCHITECTURE  
 A - 163, Sector - 136,  
 Noida - Greater Noida Expressway,  
 Noida - 201301  
 Email: sachin.agarwal@designassociates.in

MECHANICAL CONSULTANT-  
 ARK CONSULTANT, NEW DELHI  
 ELECTRICAL CONSULTANT-  
 ARK CONSULTANT, NEW DELHI  
 PLUMBING CONSULTANT-  
 ARK CONSULTANT, NEW DELHI  
 STRUCTURE CONSULTANT-  
 CE CON ENGG., NEW DELHI


PROJECT-  
**COMMERCIAL COMPLEX  
 AT POLO MARKET  
 SHILLONG**

DRAWING TITLE-  
**STILT FLOOR PLAN  
 MV CABLE TRAY LAYOUT**

DRAWING PURPOSE-  
**FOR TENDER PURPOSES ONLY**

JOB NO. -	DWG. REF. NO. -	DATE -
-----	-----	29-12-2017
SCALE -	REVISION -	DATE OF ISSUE -
1:150	R1	04.10.2019

DWG. NO. - **EL-100**

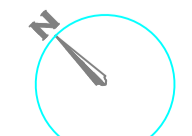	SHEET SIZE - A1	SHEET NO. - -----
	DRAWN BY - BUNTY	CHECKED BY - PANKAJ



STILT FLOOR PLAN

THIS DRAWING IS THE PROPERTY OF THE DESIGN ASSOCIATES INC. AND SHALL NOT BE COPIED OR USED IN ANY MANNER WITHOUT PRIOR PERMISSION.

**ELECTRICAL LEGEND :-**

SYMBOL	DESCRIPTION
	EMERGENCY SWITCH BOARD
	SWITCH BOARD
	(1x18WATT) LED LIGHT
	(1x18WATT) LED LIGHT FOR EMERGENCY
	(1x28WATT) CEILING TUBE LIGHT
	(2x28WATT) CEILING TUBE LIGHT
	(1x18WATT) WALL MOUNTED LIGHT
	1x20W BULK HEAD LIGHT
	6A SWITCH SOCKET
	6/16A 5PIN SWITCH SOCKET
	6A 5PIN SWITCH SOCKET FOR UPS
	CCTV CAMERA
	DISTRIBUTION BOARD
	25MMØ CONDUIT FOR LIGHT
	25MMØ CONDUIT FOR EMERGENCY
	25MMØ CONDUIT FOR POWER
	25MMØ CONDUIT FOR UPS

NO. OF PRINTS	DATE	ISSUED TO	REMARKS

REVISION	DATE	DESCRIPTION	BY
R0	28.11.2017	FOR APPROVAL	NIKHIL TYAGI
R1	02.01.2018	FOR APPROVAL	NIKHIL TYAGI
R2	31.01.2018	FOR APPROVAL	NIKHIL TYAGI
R3	21.05.2018	FOR APPROVAL	NIKHIL TYAGI
R4	04.10.2019	FOR APPROVAL	BUNTY

ASSOCIATE ARCHITECTS-  
**DESIGN ASSOCIATES INC.**  
 ARCHITECTURE  
 A - 163, Sector - 136,  
 Noida - Greater Noida Expressway,  
 Noida - 201301  
 Email: sachin.agarwal@designassociates.in


MECHANICAL CONSULTANT-  
 ARK CONSULTANT, NEW DELHI  
 ELECTRICAL CONSULTANT-  
 ARK CONSULTANT, NEW DELHI  
 PLUMBING CONSULTANT-  
 ARK CONSULTANT, NEW DELHI  
 STRUCTURE CONSULTANT-  
 CE CON ENGG., NEW DELHI  
 PROJECT-

**COMMERCIAL COMPLEX  
 AT POLO MARKET  
 SHILLONG**

DRAWING TITLE-  
**STILT FLOOR PLAN  
 POWER & LV & UPS LAYOUT**

DRAWING PURPOSE-  
**FOR TENDER PURPOSES ONLY**

JOB NO. -	DWG. REF. NO. -	DATE -
		29-12-2017
SCALE -	REVISION -	DATE OF ISSUE -
1:150	R4	04.10.2019
DWG. NO. -	EL-101	
SHEET SIZE -	A1	SHEET NO. -
DRAWN BY -	BUNTY	CHECKED BY -
		PANKAJ

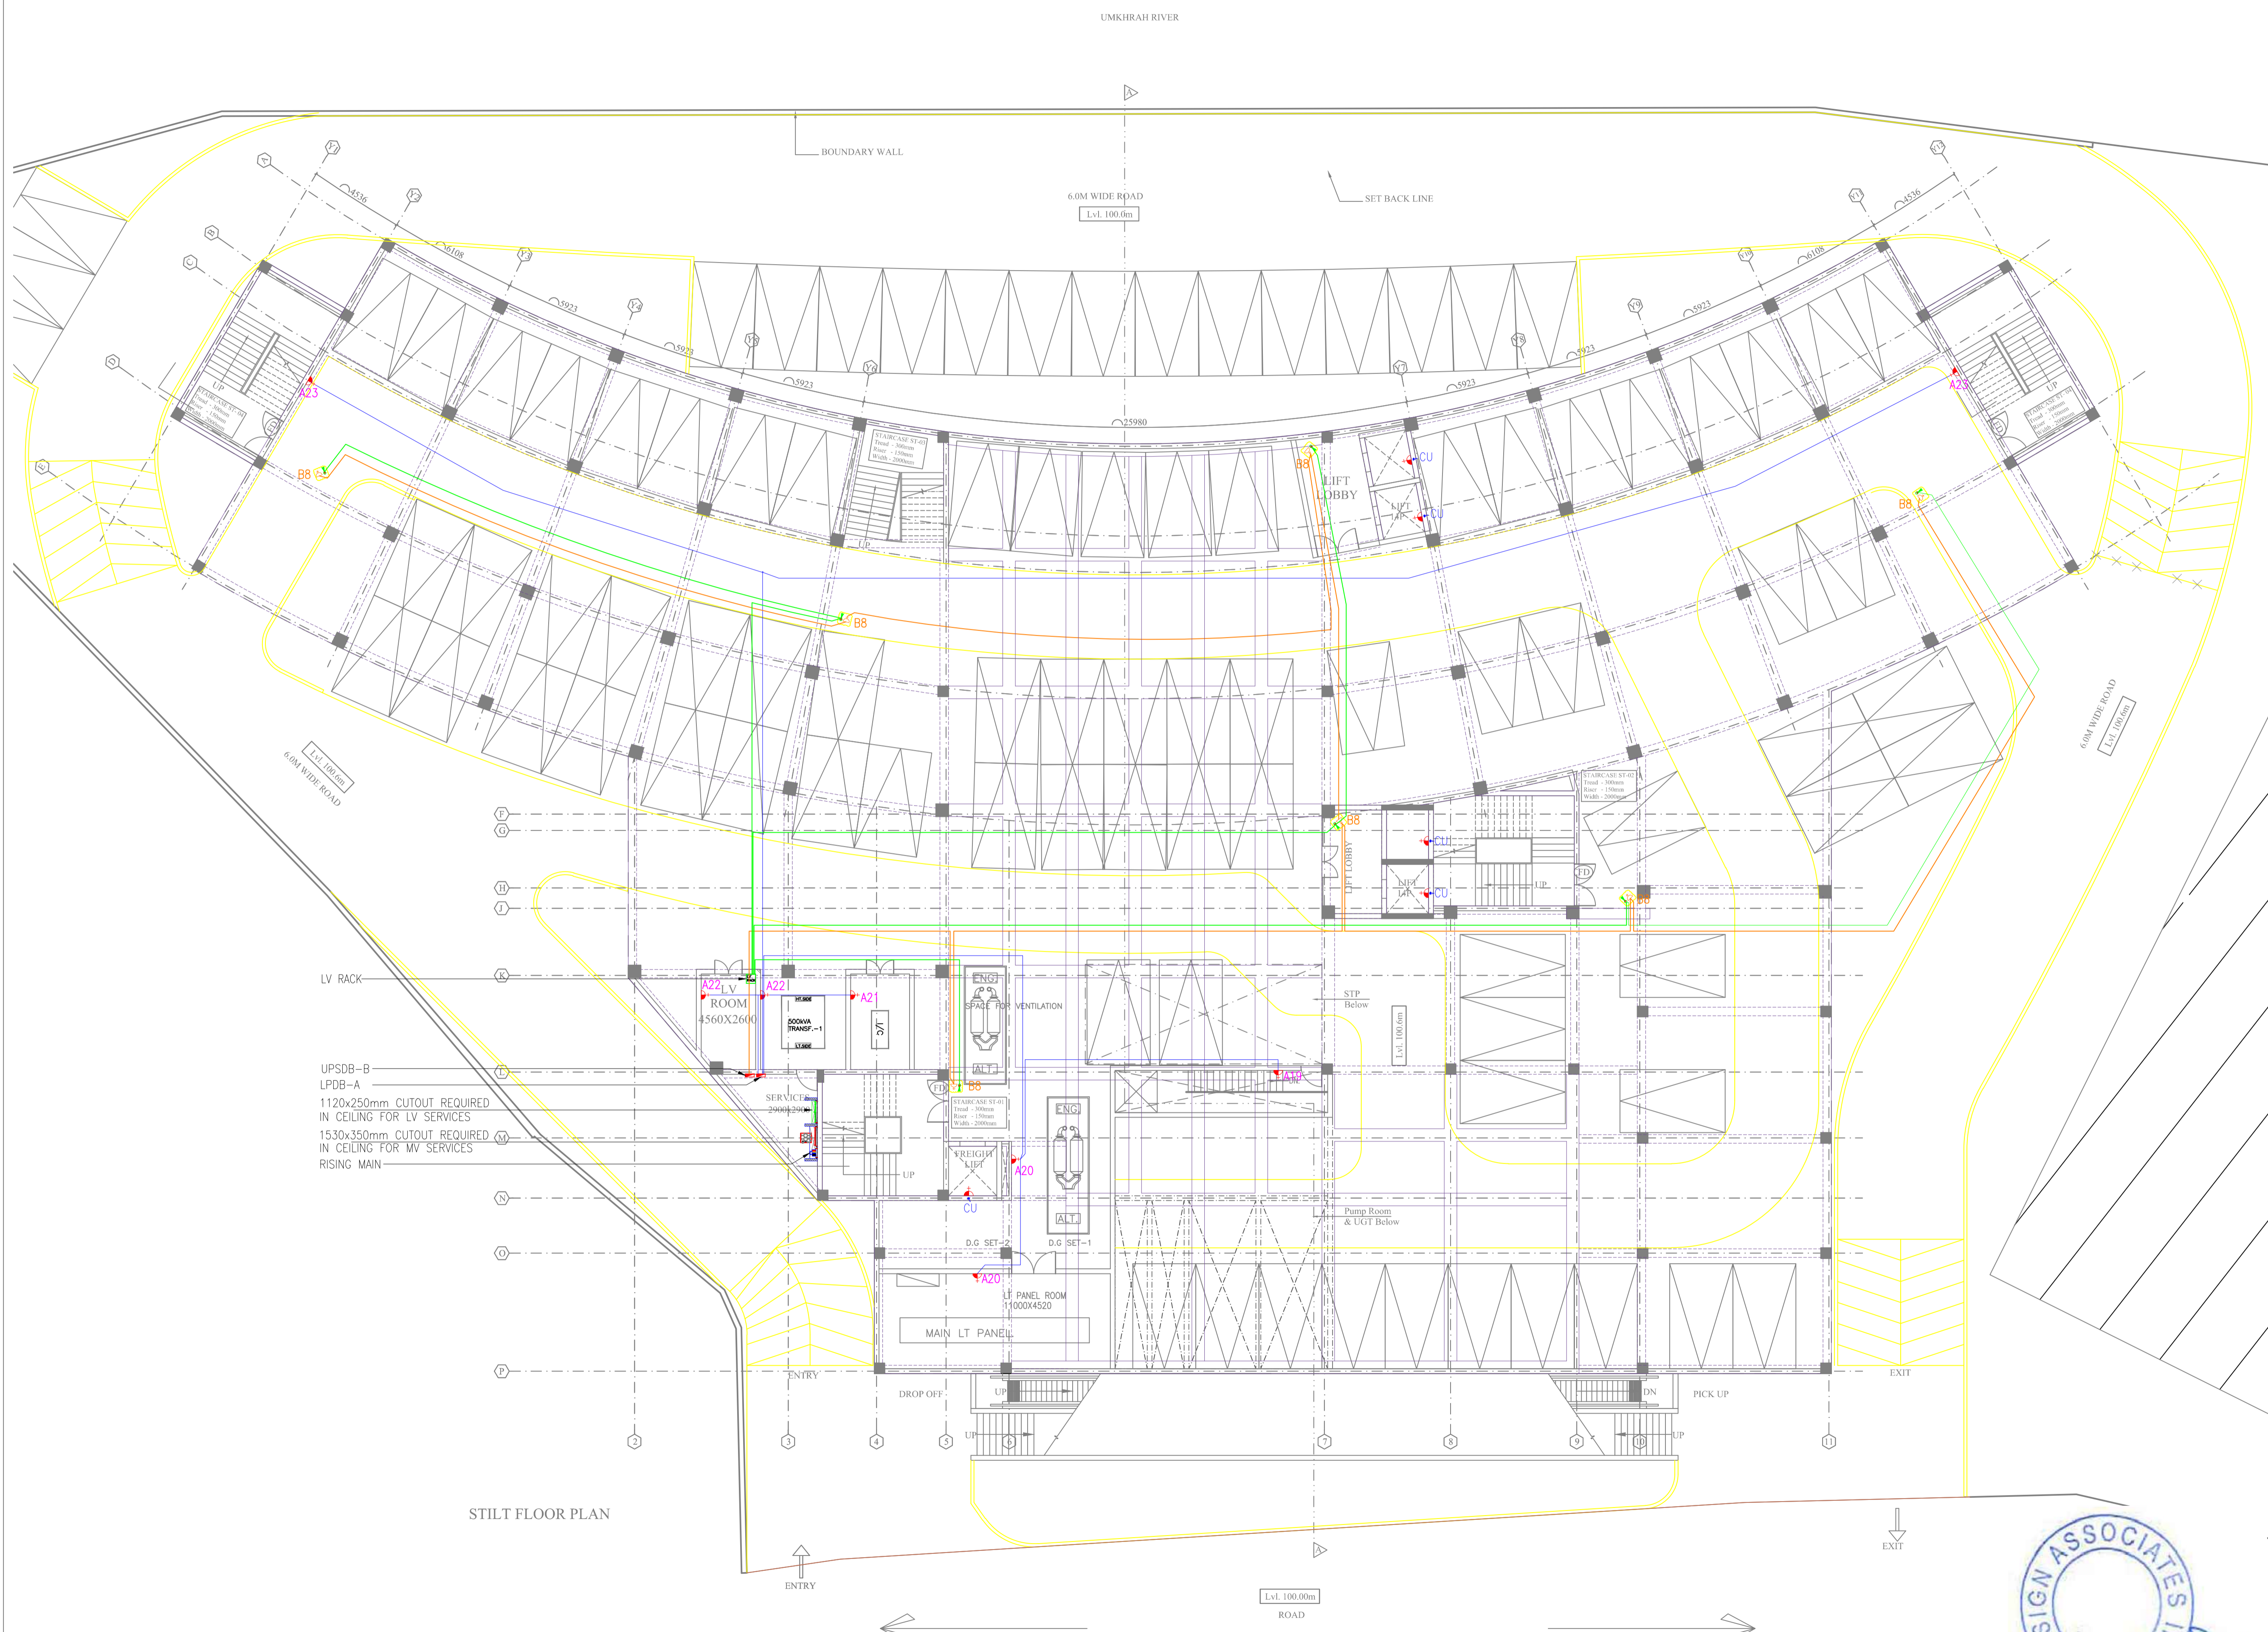

STILT FLOOR PLAN

